
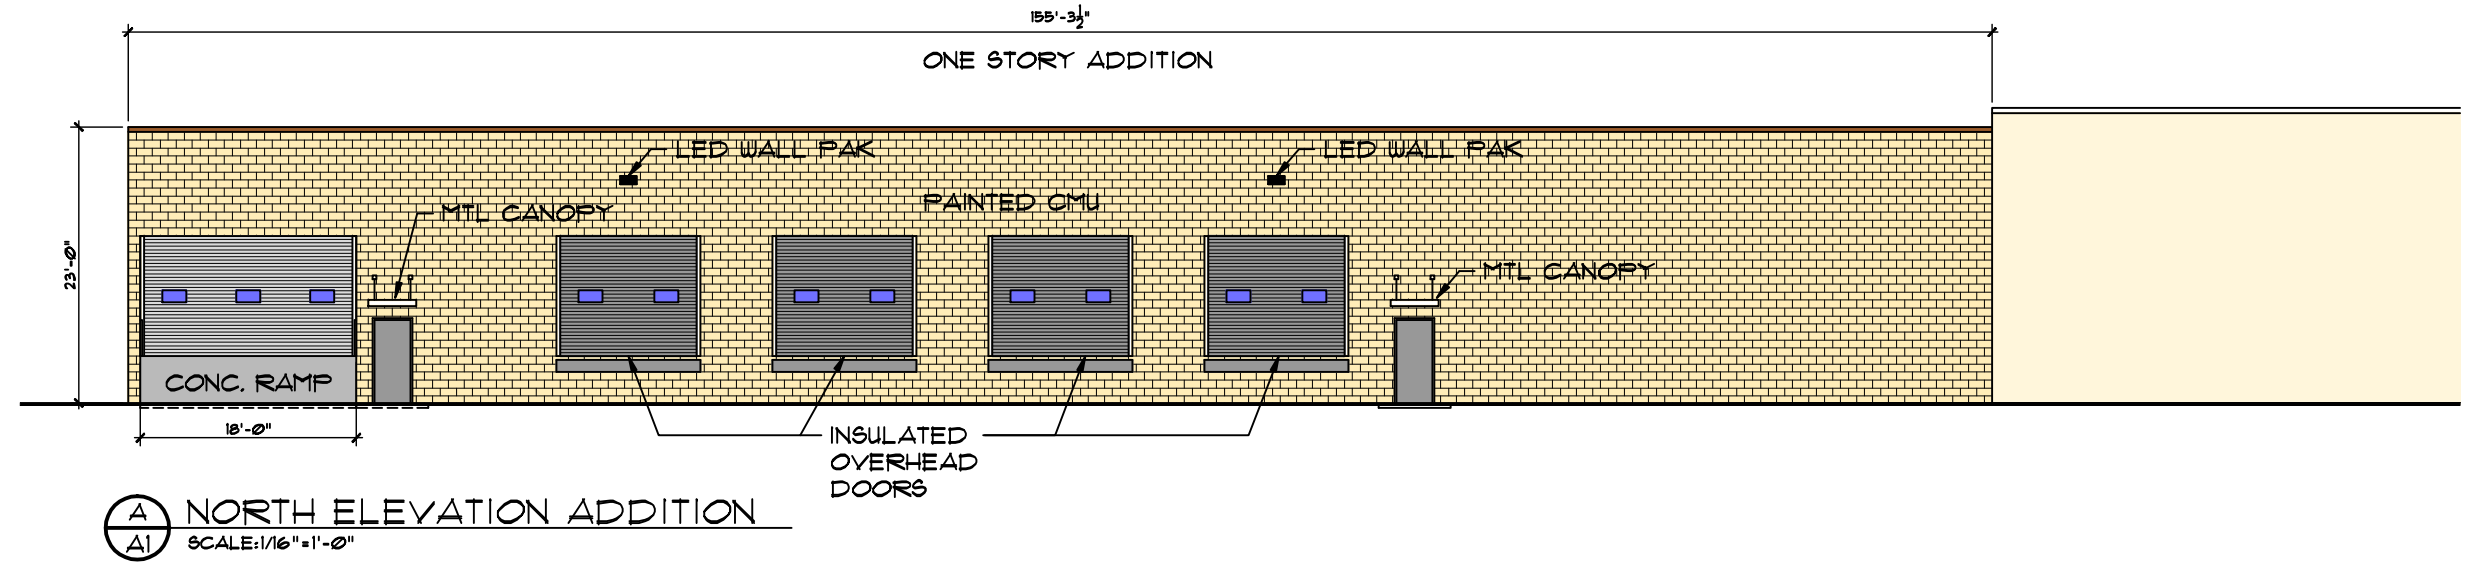


PROPOSED FLOOR PLAN
SCALE: 1/16" = 1'-0"

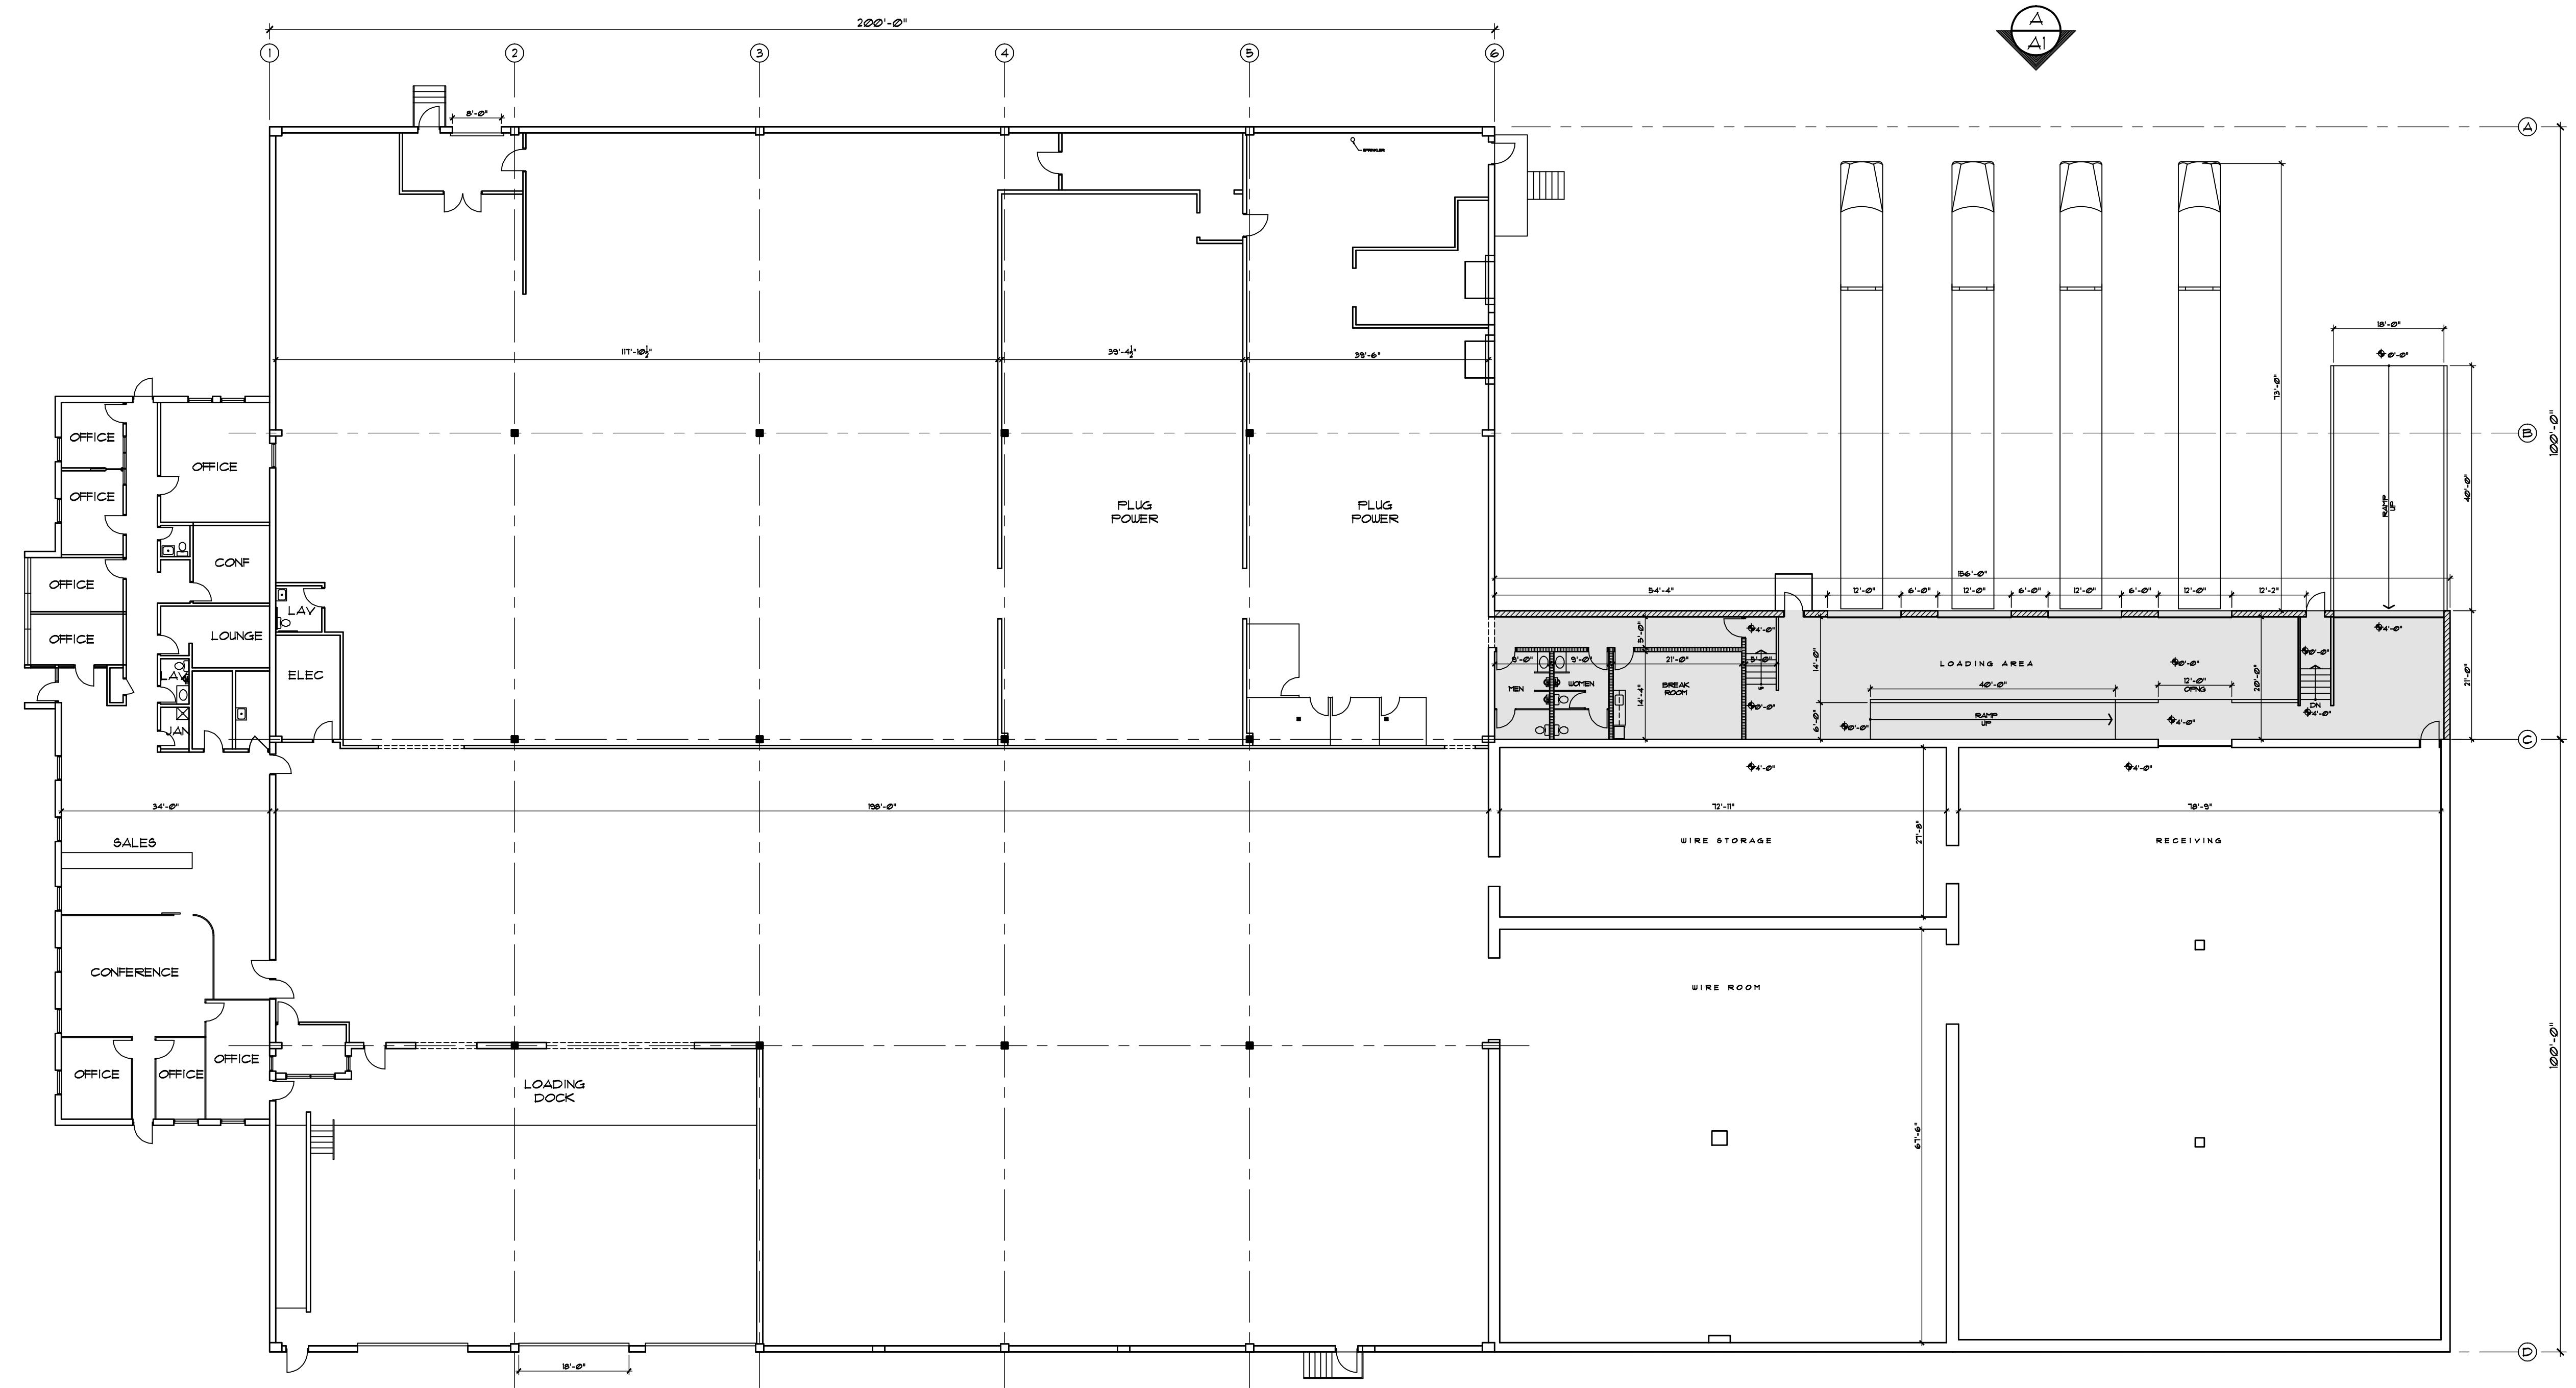

DATE: 02/09/22
PROJECT NO.: 02/09/22
FULL NAME: ONES
SCALE: 1/16" = 1'-0"

DATE: 02/09/22
PROJECT NO.: 02/09/22
FULL NAME: ONES
SCALE: 1/16" = 1'-0"

PROJECT NO.:
DESIGNED BY:
DRAWN BY:
CHECKED BY:
SCALE:
DATE:
AS NOTED

PROPOSED FLOOR PLAN

**HARRIS A. SANDERS
ARCHITECTS, P.C.**
252 WASHINGTON AVENUE, ALBANY, NEW YORK 12210
GREEN MOUNTAIN ELECTRIC SUPPLY
875 BROADWAY
ALBANY, NEW YORK

SHEET NO.

A1