

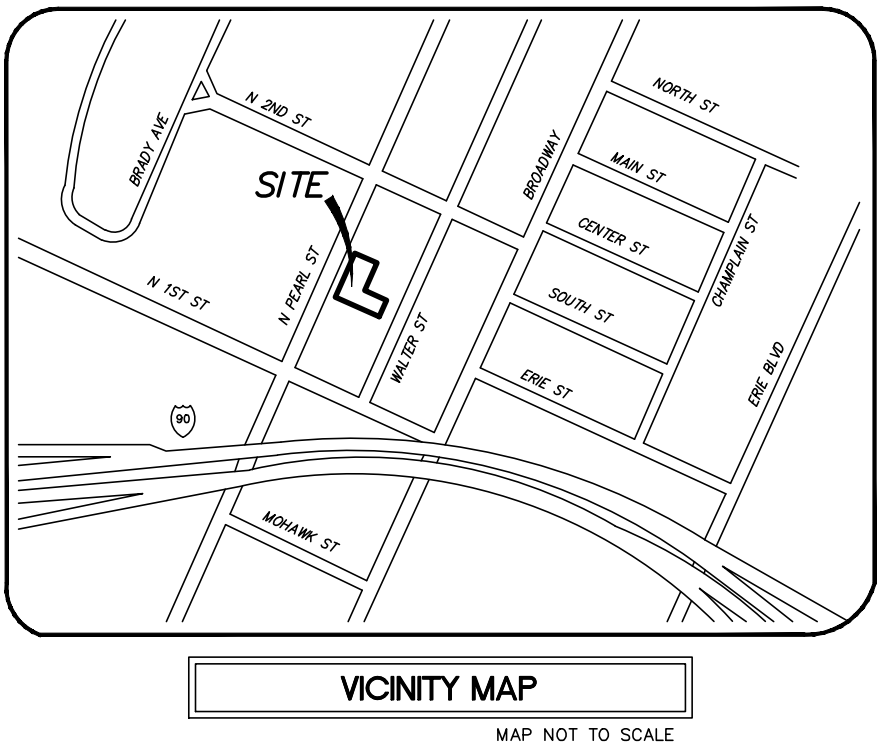
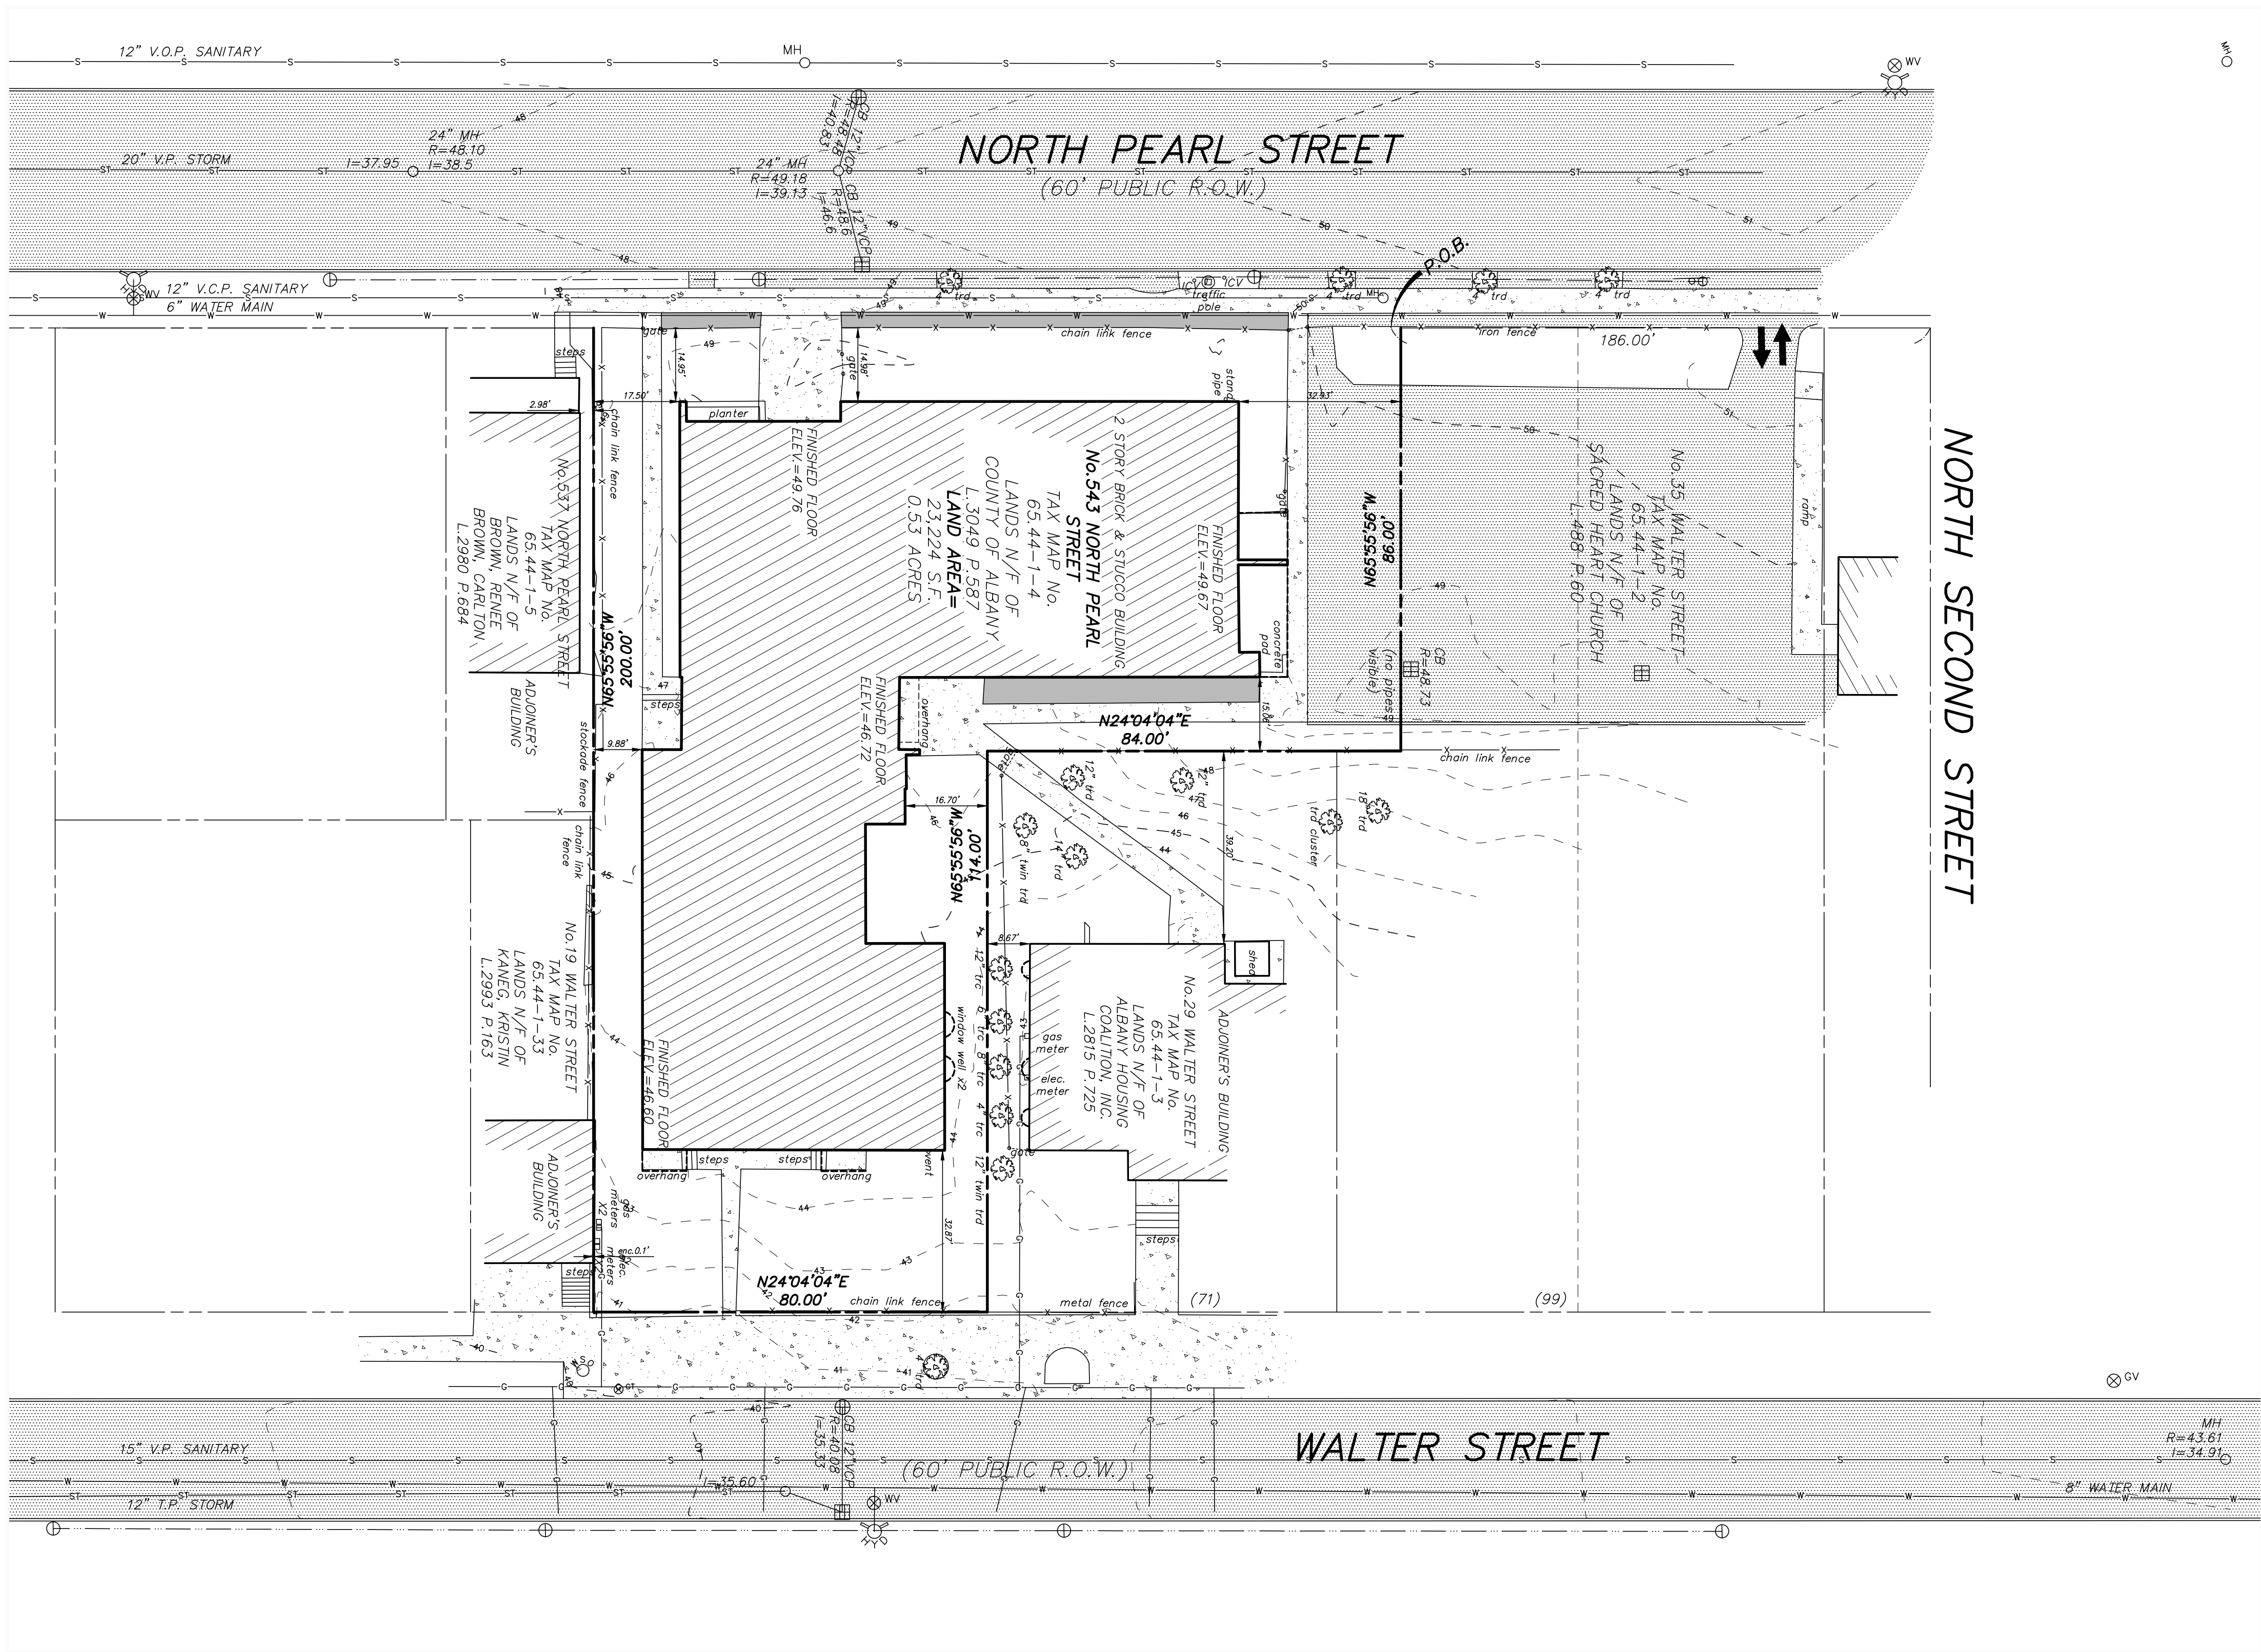


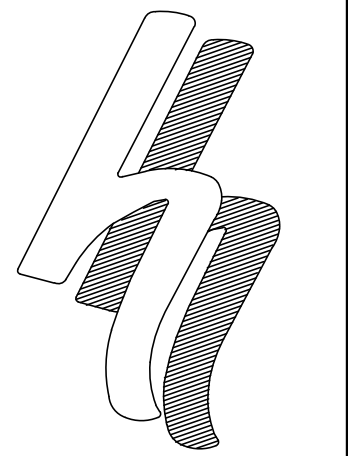

LEGEND			
R.O.W.	RIGHT OF WAY		MONUMENT
No.	NUMBER		IRON ROD
enc.	ENCROACHMENT		MANHOLE
P.O.B.	POINT OF BEGINNING		CATCHBASIN
S.F.	SQUARE FEET		SIGN
N/F	NOW OR FORMERLY		BOLLARD
Ft.	FEET		FENCE LINE
Deg.	DEGREE		GUARD RAIL
R	RECORD		OVERHEAD WIRE, UTILITY POLE & GUY WIRE
M	MEASURED		TRAFFIC FLOW ACCESS AREA
N	NORTH		WATER SHUT OFF
S	SOUTH		WATER VALVE
E	EAST		HYDRANT
W	WEST		GAS VALVE
tel.	TELEPHONE		GAS TEST
elec.	ELECTRIC		STREET LIGHT
L.	LIBER		LIGHT POLE
P.	PAGE		CONCRETE
	HANDICAPPED PARKING SPACE		PAVEMENT
	PARKING METER		


- SCHEDULE OF DRAWINGS
- C1 EXISTING CONDITIONS PLAN
 - C2 DEMOLITION PLAN
 - C3 SITE PLAN
 - C4 UTILITIES PLAN
 - C5 DETAILS
 - C6 DETAILS
 - C7 DETAILS
 - C8 LANDSCAPE PLAN
 - C9 STORM WATER MANAGEMENT PLAN
 - C10 LIGHTING PLAN

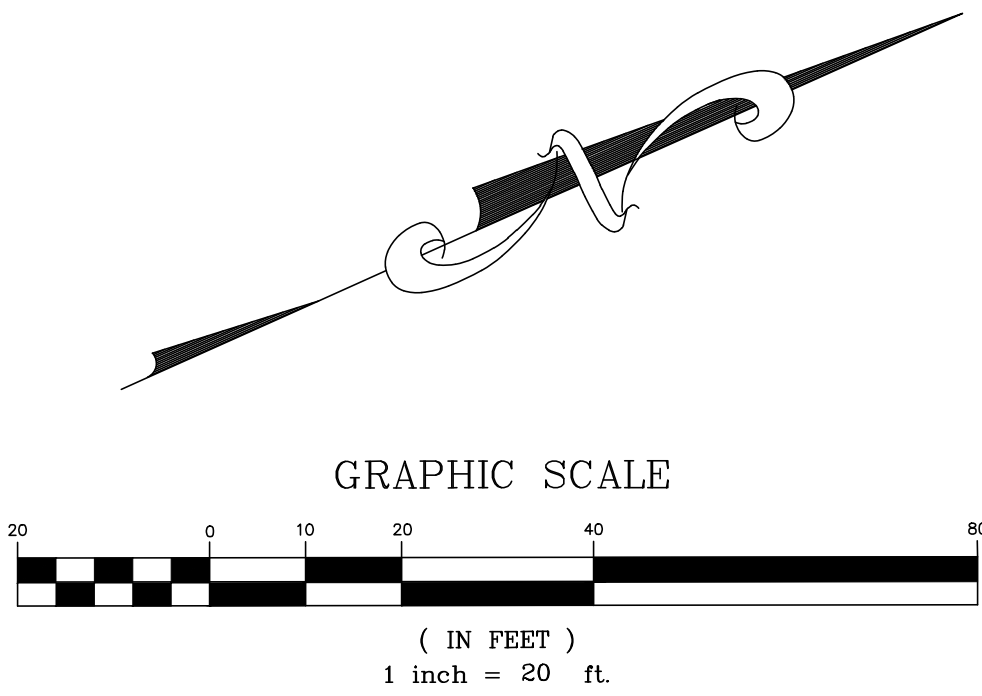

HERSHBERG & HERSHBERG
Consulting Engineers and Land Surveyors

18 Locust Street
Albany, New York 12203

ALTERATION OF THIS DOCUMENT EXCEPT BY A LICENSED PROFESSIONAL ENGINEER OR LAND SURVEYOR, IS ILLEGAL

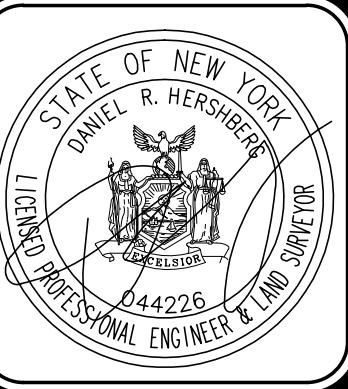

REMARKS	DATE
1/15/19	
1/15/19 COMMENTS	
DEPT/ENGINEERING	
REVISIONS	

EXISTING CONDITIONS PLAN
PROPOSED APARTMENTS
543 NORTH PEARL STREET
ALBANY, NY

FILE: 180267


SCALE: 1"=20'

CHK: DPH

BY: AS


DATE: 11/12/18

180267-LONG

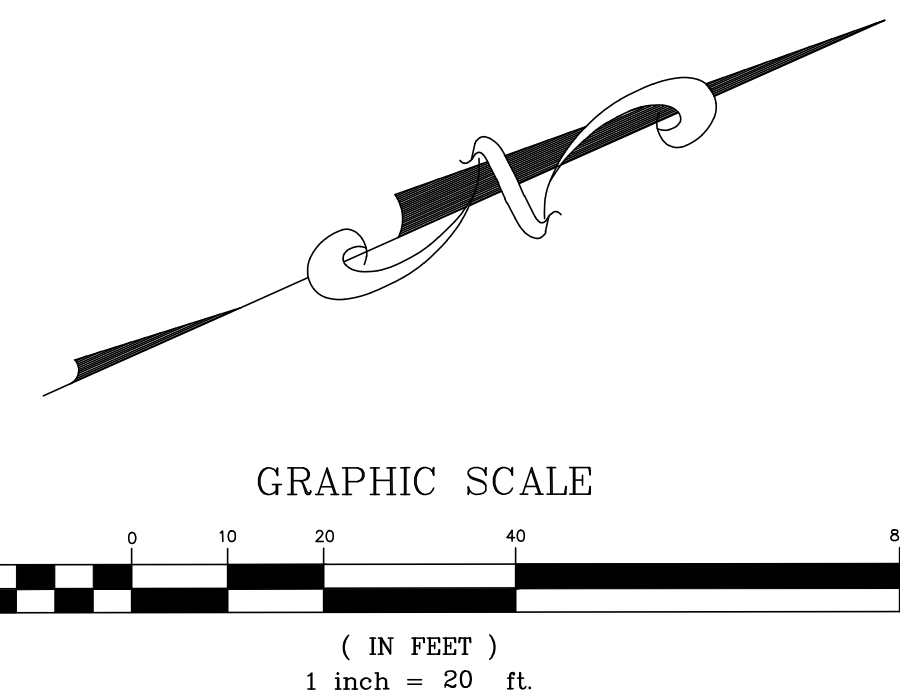

R.O.W.	RIGHT OF WAY		MONUMENT
No.	NUMBER		IRON ROD
enc.	ENCROACHMENT	MH	MANHOLE
P.O.B.	POINT OF BEGINNING		CATCHBASIN
S.F.	SQUARE FEET		SIGN
N/F	NOW OR FORMERLY	•	BOLLARD
Ft.	FEET	— x —	FENCE LINE
Deg.	DEGREE		GUARD RAIL
R	RECORD		OVERHEAD WIRE, UTILITY POLE & GUY WIRE
M	MEASURED		TRAFFIC FLOW ACCESS AREA
N	NORTH		WATER SHUT OFF
S	SOUTH		WATER VALVE
E	EAST		HYDRANT
W	WEST		GAS VALVE
tel.	TELEPHONE		GAS TEST
elec.	ELECTRIC		STREET LIGHT
L.	LIBER		LIGHT POLE
P.	PAGE		CONCRETE
	HANDICAPPED PARKING SPACE		
0	PARKING METER		



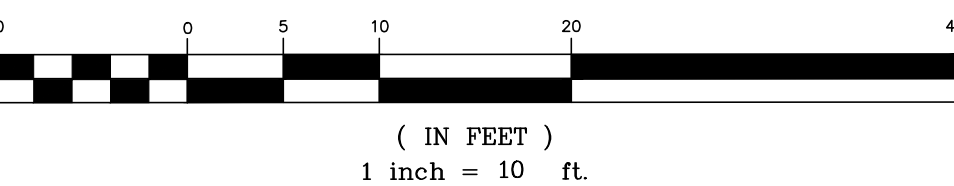




2/C5 CONCRETE WALK DETAIL
NOT TO SCALE



4 / C5 GRANITE DROP CURB DETAIL

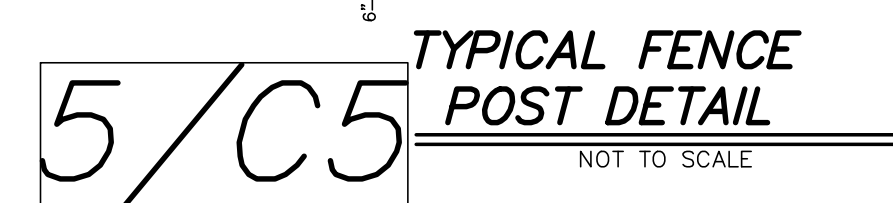


7/C5 **TRENCH DETAIL**
NOT TO SCALE



*Consulting Engineers
and Land Surveyors*

18 Locust Street
Albany, New York 12203

ALTERATION OF THIS
DOCUMENT EXCEPT BY A
LICENSED PROFESSIONAL
ENGINEER OR LAND
SURVEYOR, IS ILLEGAL

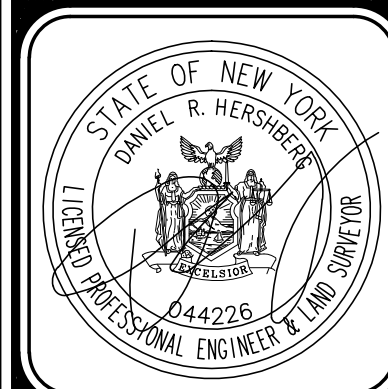

REMARKS	DATE
DEPT/ENGINEERING 1/15/19 COMMENTS	1/18/19

REVISIONS

**DETAILS
PROPOSED APARTMENTS
543 NORTH PEARL STREET
ALBANY, NY**

1.DWG

12/18

DRH

Y: AS

SCALE: 1"=10'


FILE: 180267

C5



18 Locust Street
Albany, New York 1220

ALTERATION OF THIS
DOCUMENT EXCEPT BY A
LICENSED PROFESSIONAL
ENGINEER OR LAND
SURVEYOR, IS ILLEGAL

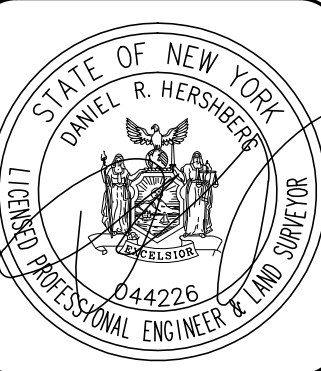

REMARKS	DATE
DEPT/ENGINEERING 1/15/19 COMMENTS	1/18/19

REVISIONS

DETAILS
PROPOSED APARTMENTS
543 NORTH PEARL STREET
ALBANY, NY

180267-1 DMC

DATE: 11/19/98


K. 0811

BY: AS


SCAF. 1990.

FILE# 180267


C7

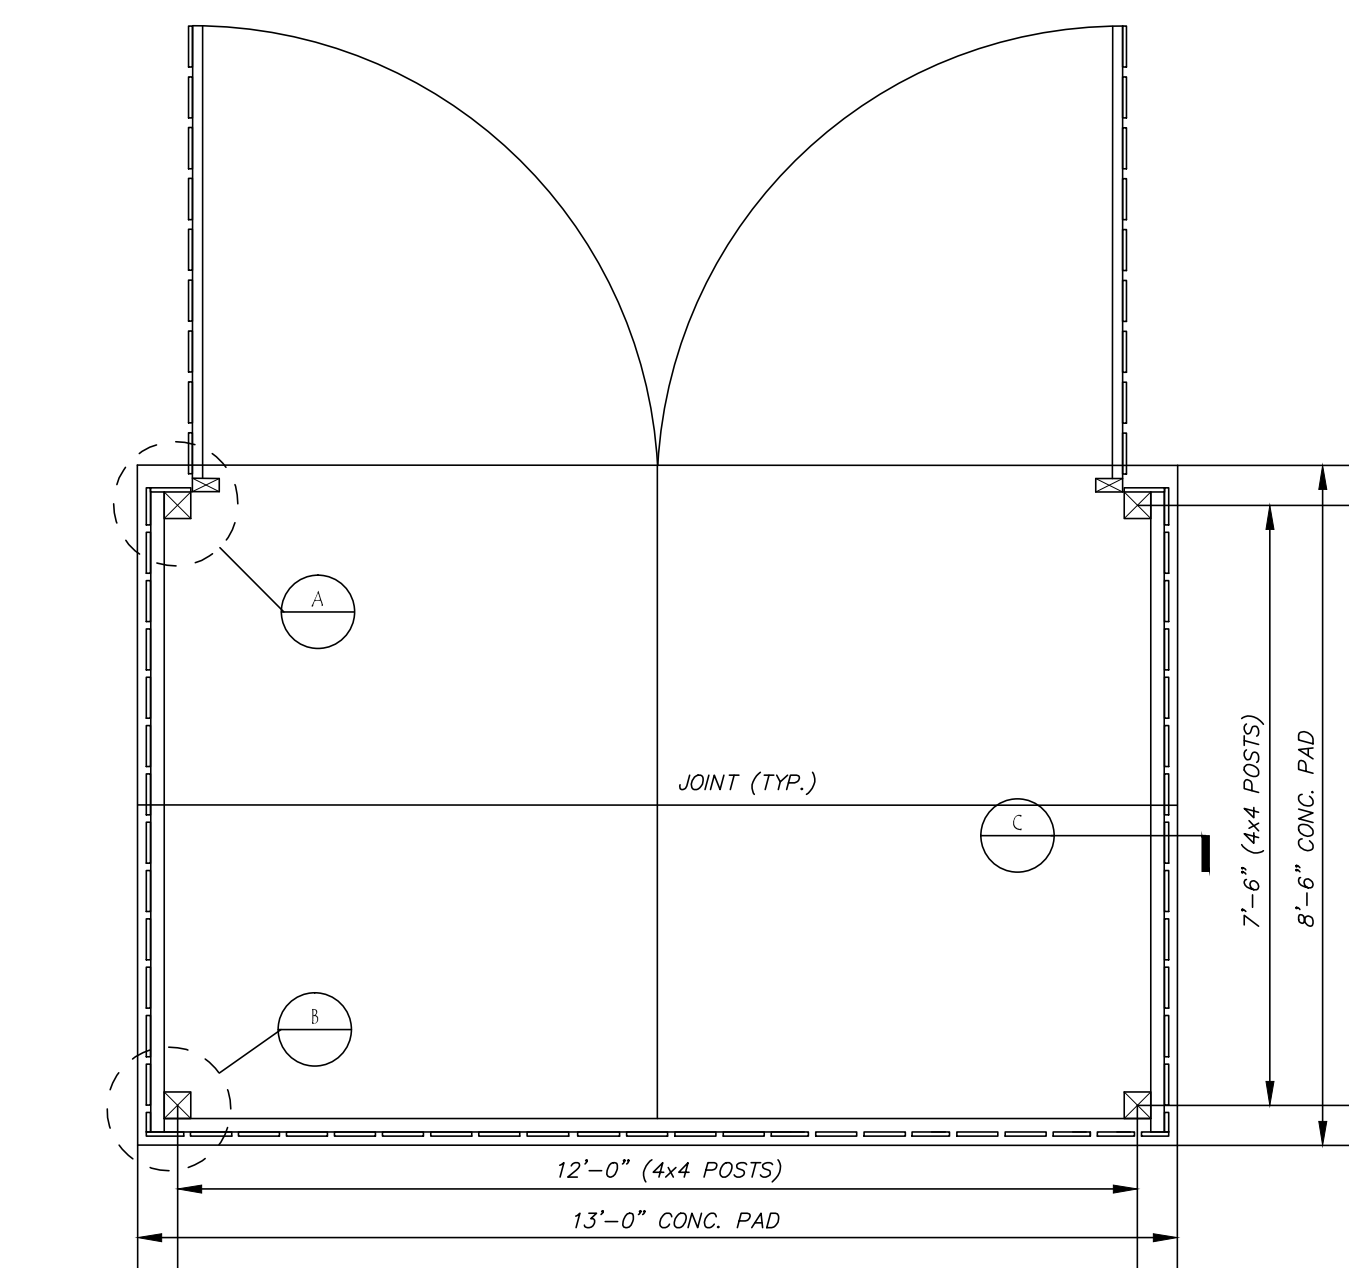


TRASH ENCLOSURE

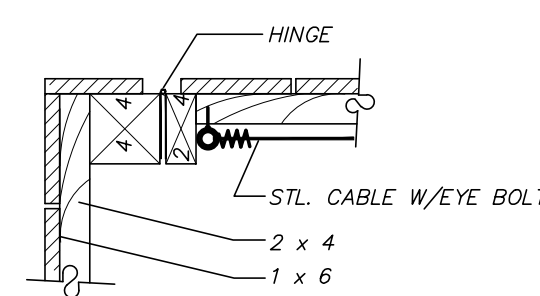


SECTION @ GATE HINGE

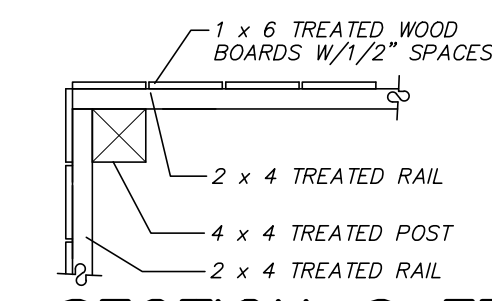


SECTION @ FENCE POST

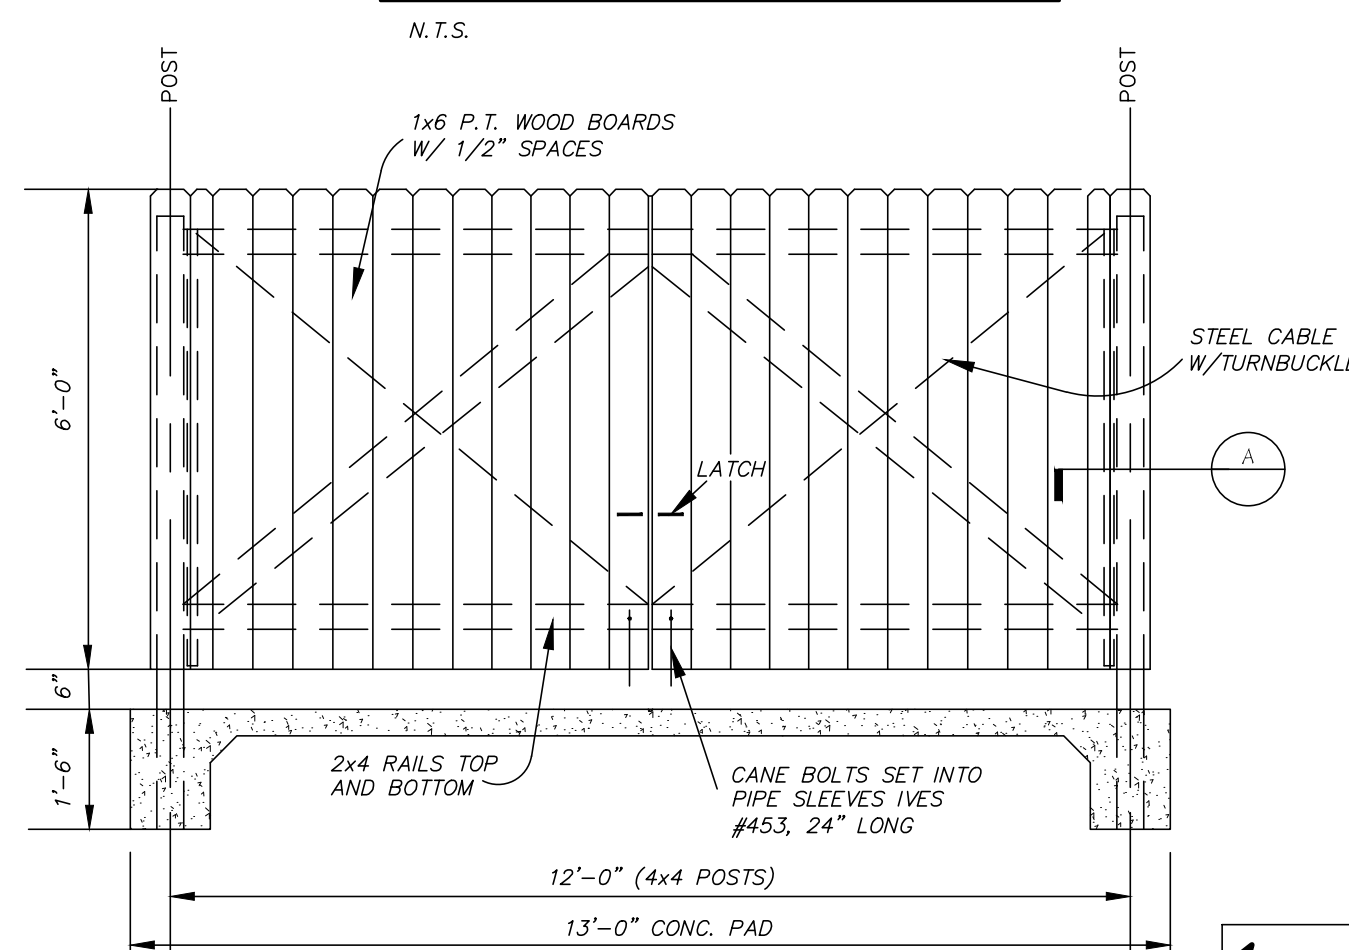


FRONT ELEVATION

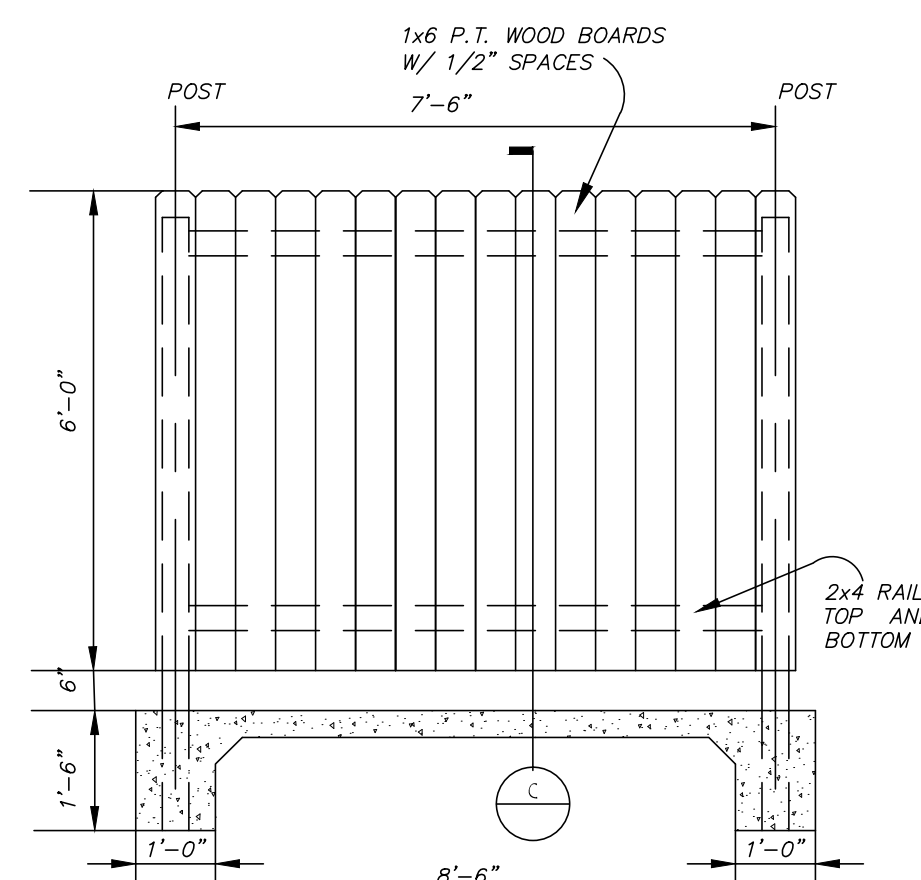

SIDE ELEVATION

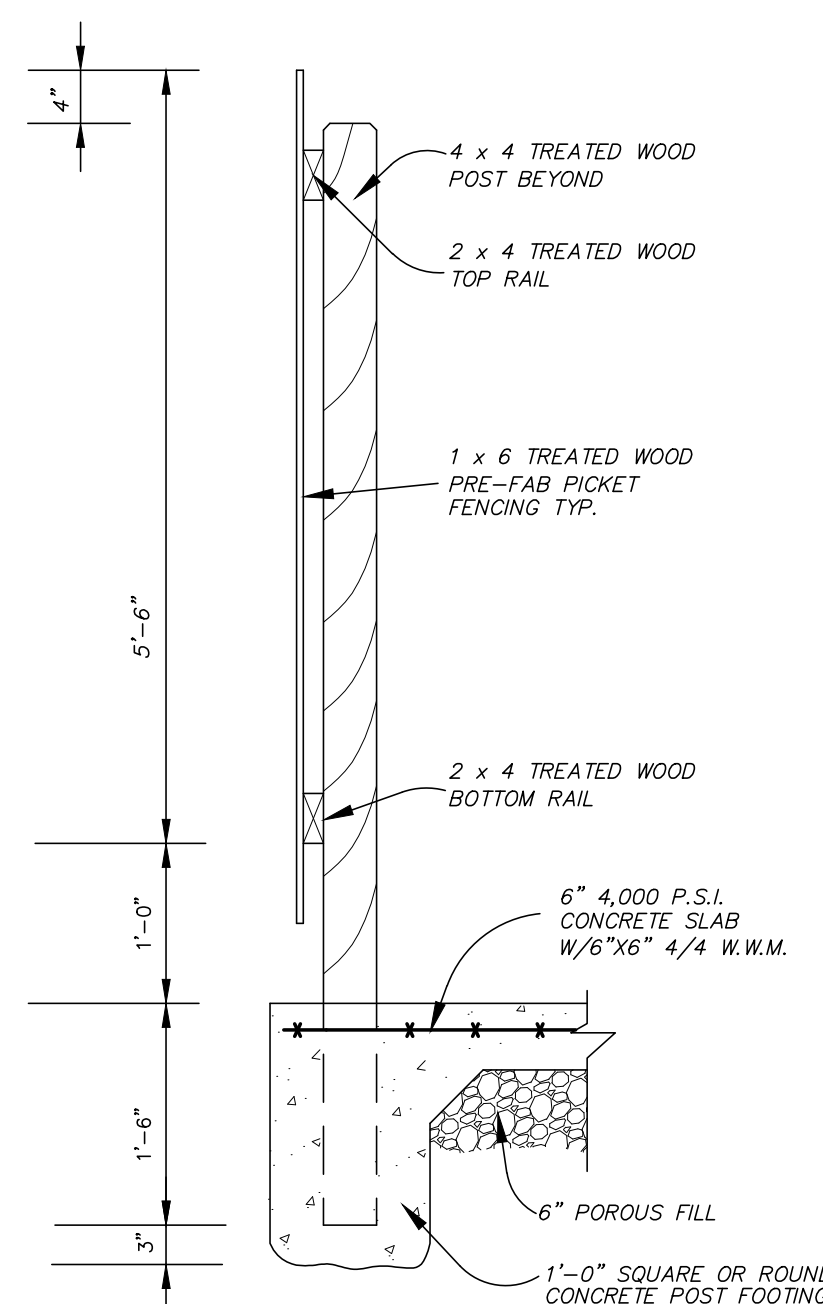

SECTION


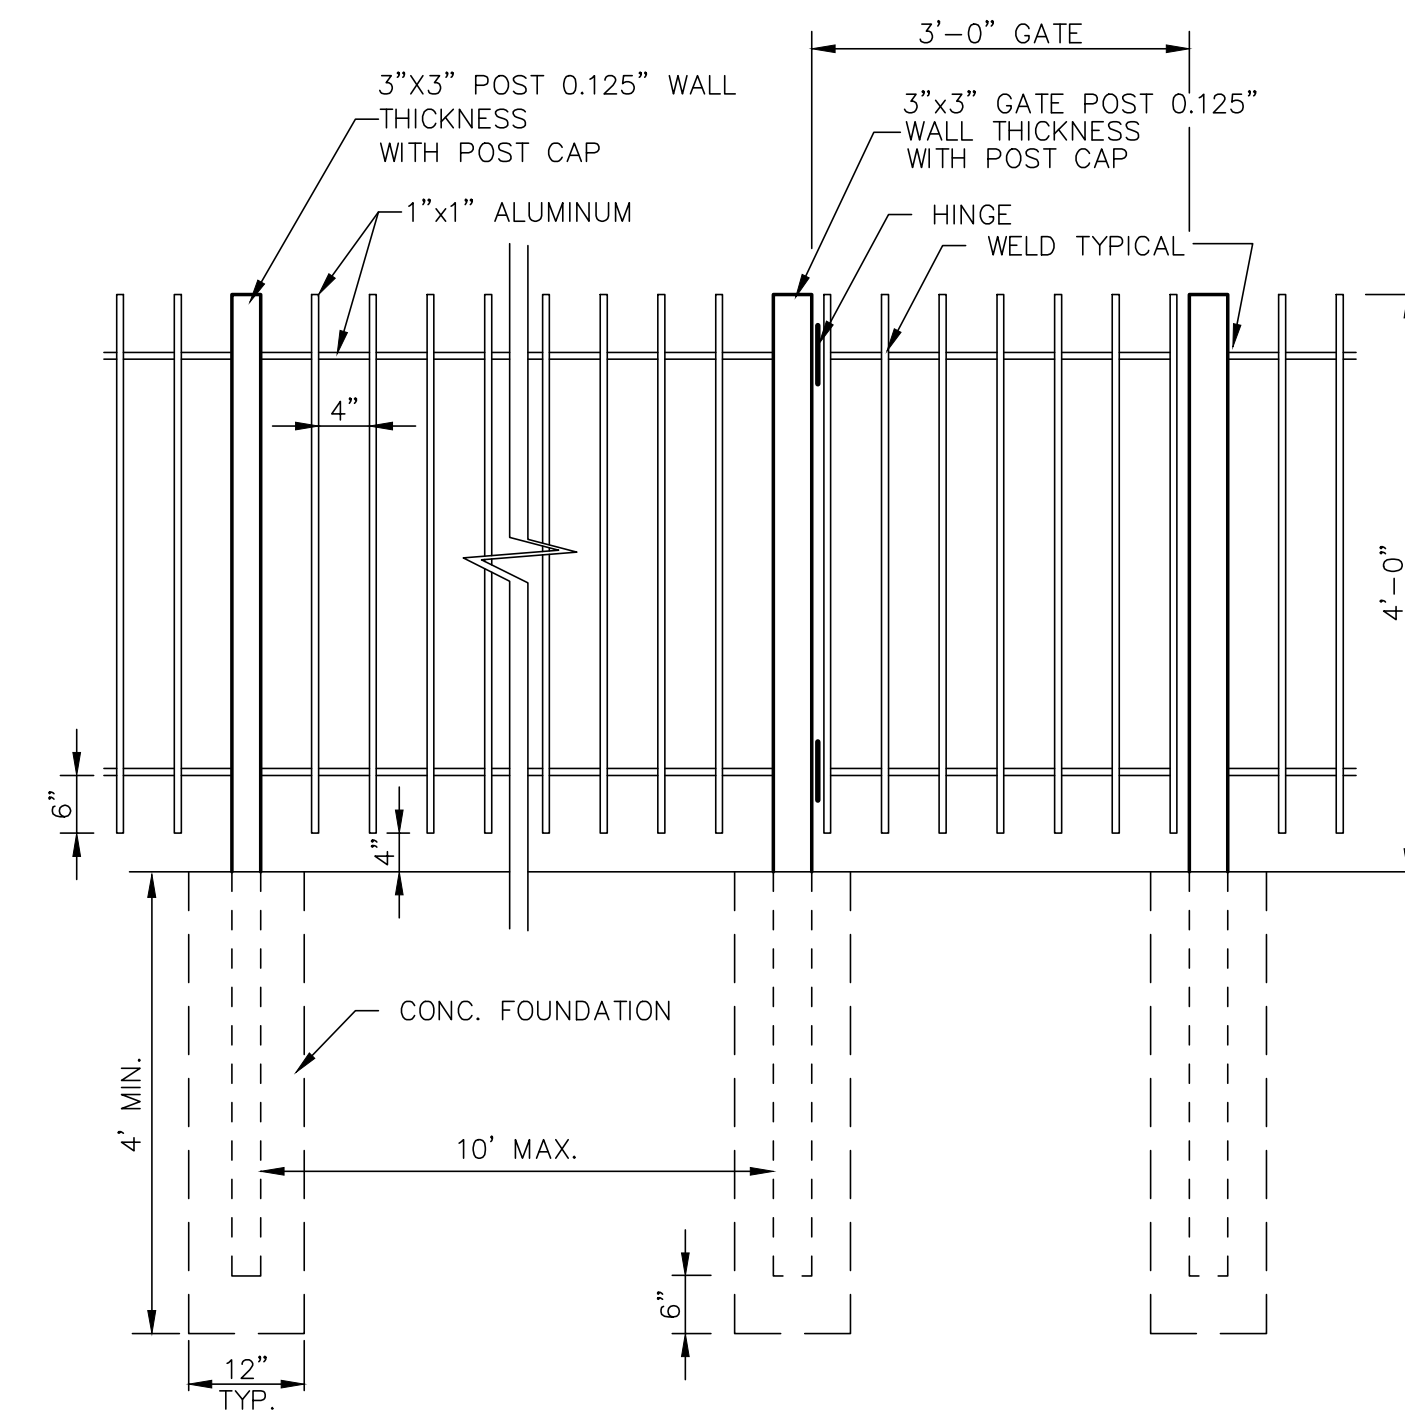




NOTE:

1. FENCE TO BE STYLE EFF-20 WITH CIRCLE PATTERN, COLOR: BLACK, INDIVIDUAL GRADE AS MANUFACTURED BY ELITE FENCE PRODUCTS, INC. OR APPROVED EQUAL.
2. PROVIDE LOCKING HASP, SUBMIT SHOP DRAWINGS FOR FENCE & GATE FOR APPROVAL.
3. EXACT DIMENSIONS SHALL BE COORDINATED WITH FENCE MANUFACTURER.


2/C7 DECORATIVE METAL FENCE DETAIL
NOT TO SCALE

TRASH ENCLOSURE DETAILS

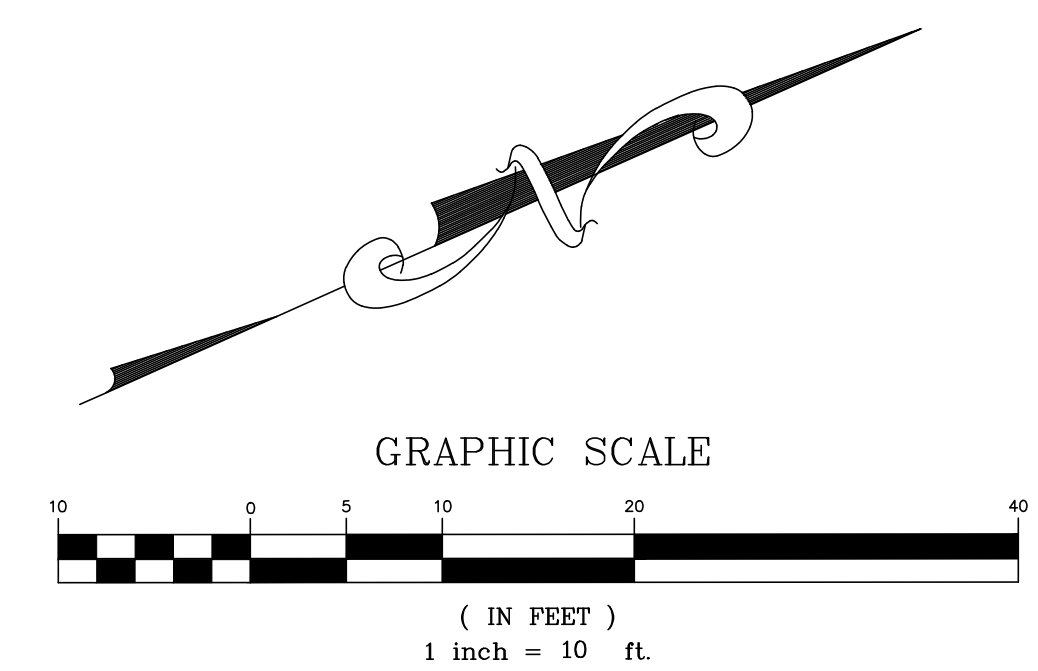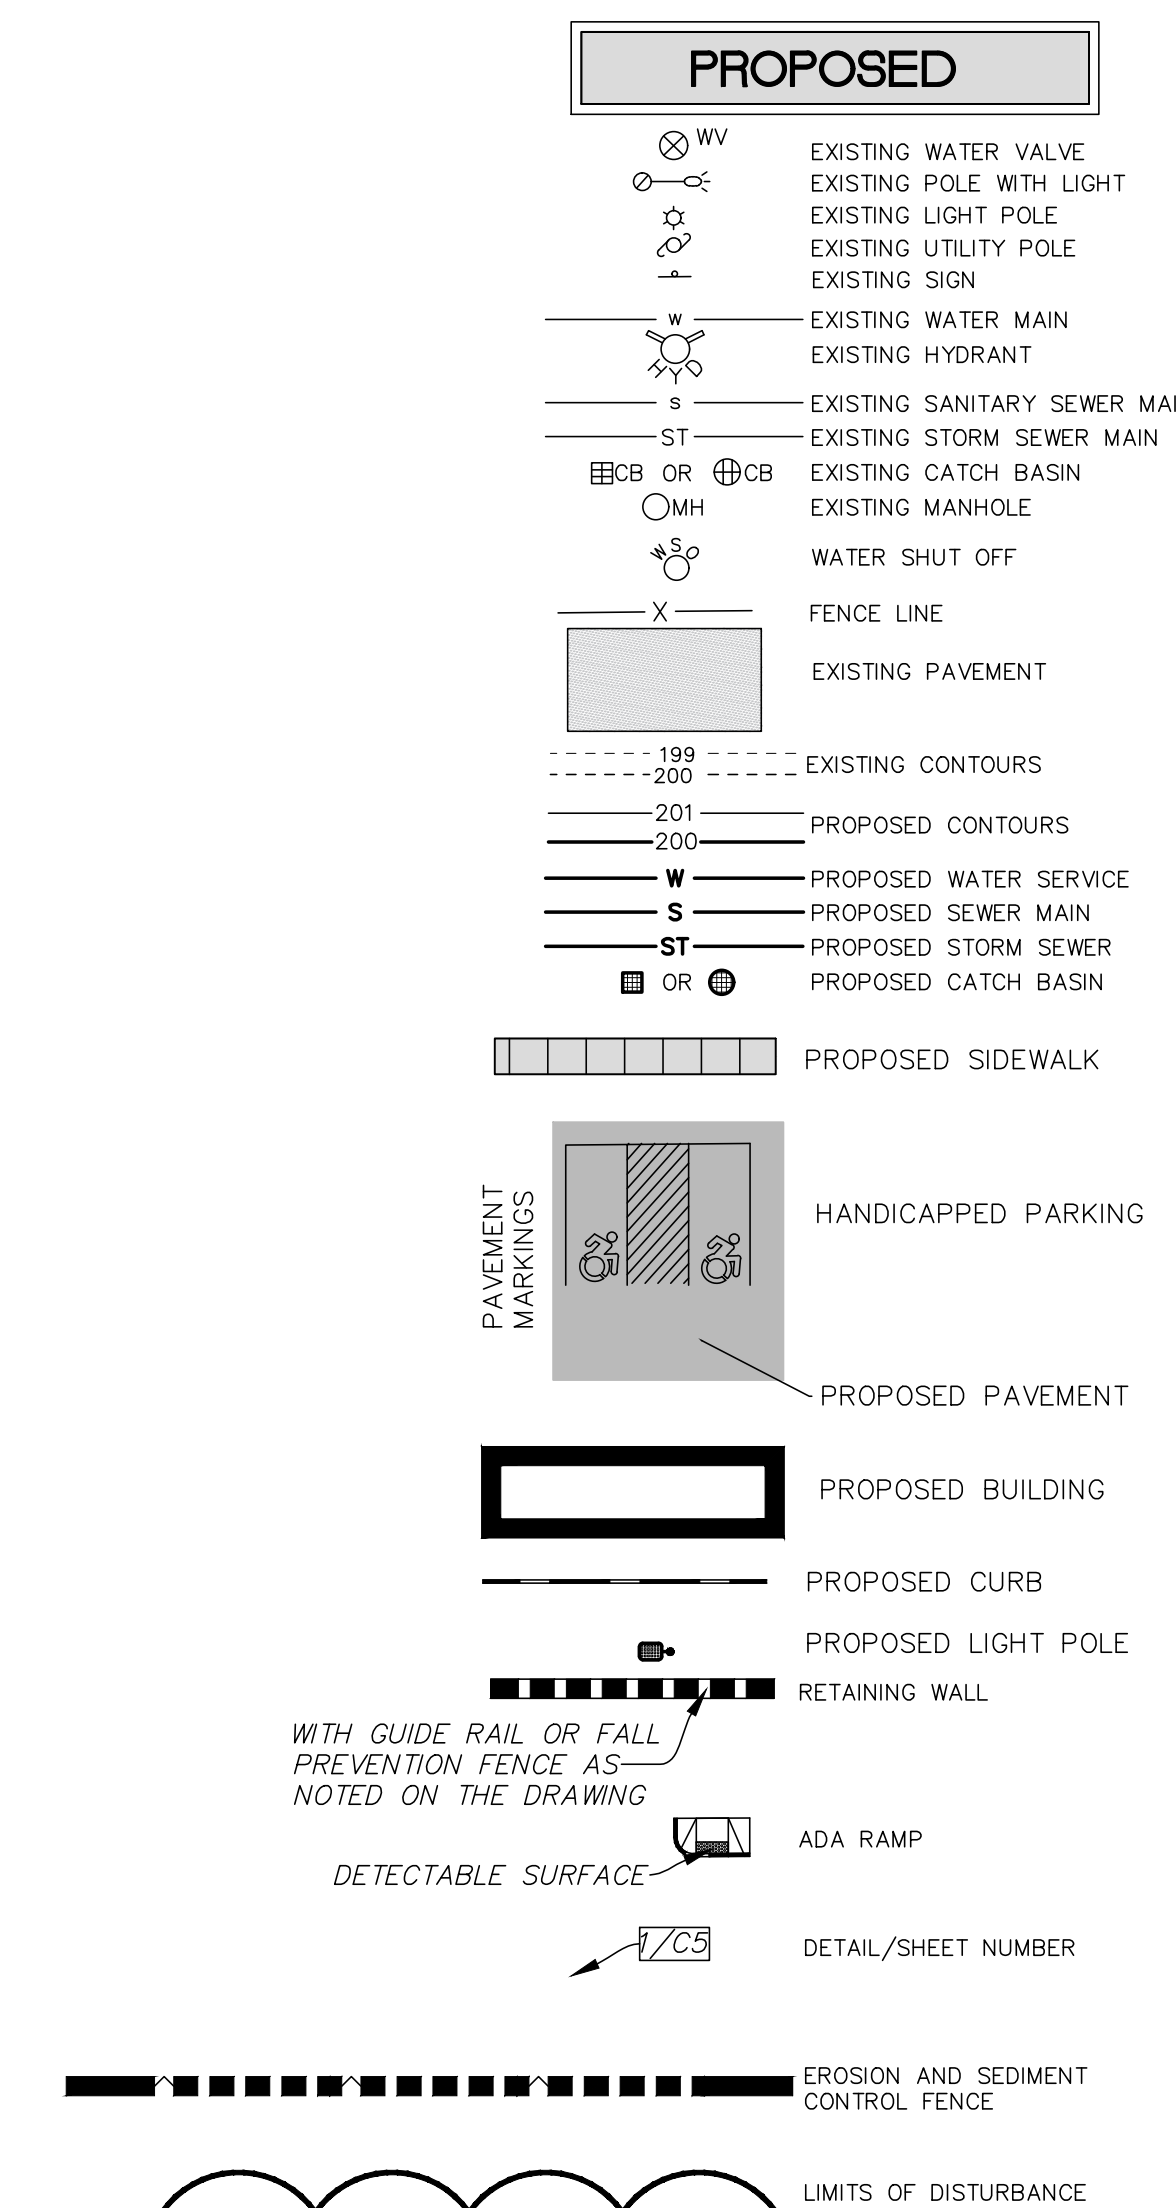

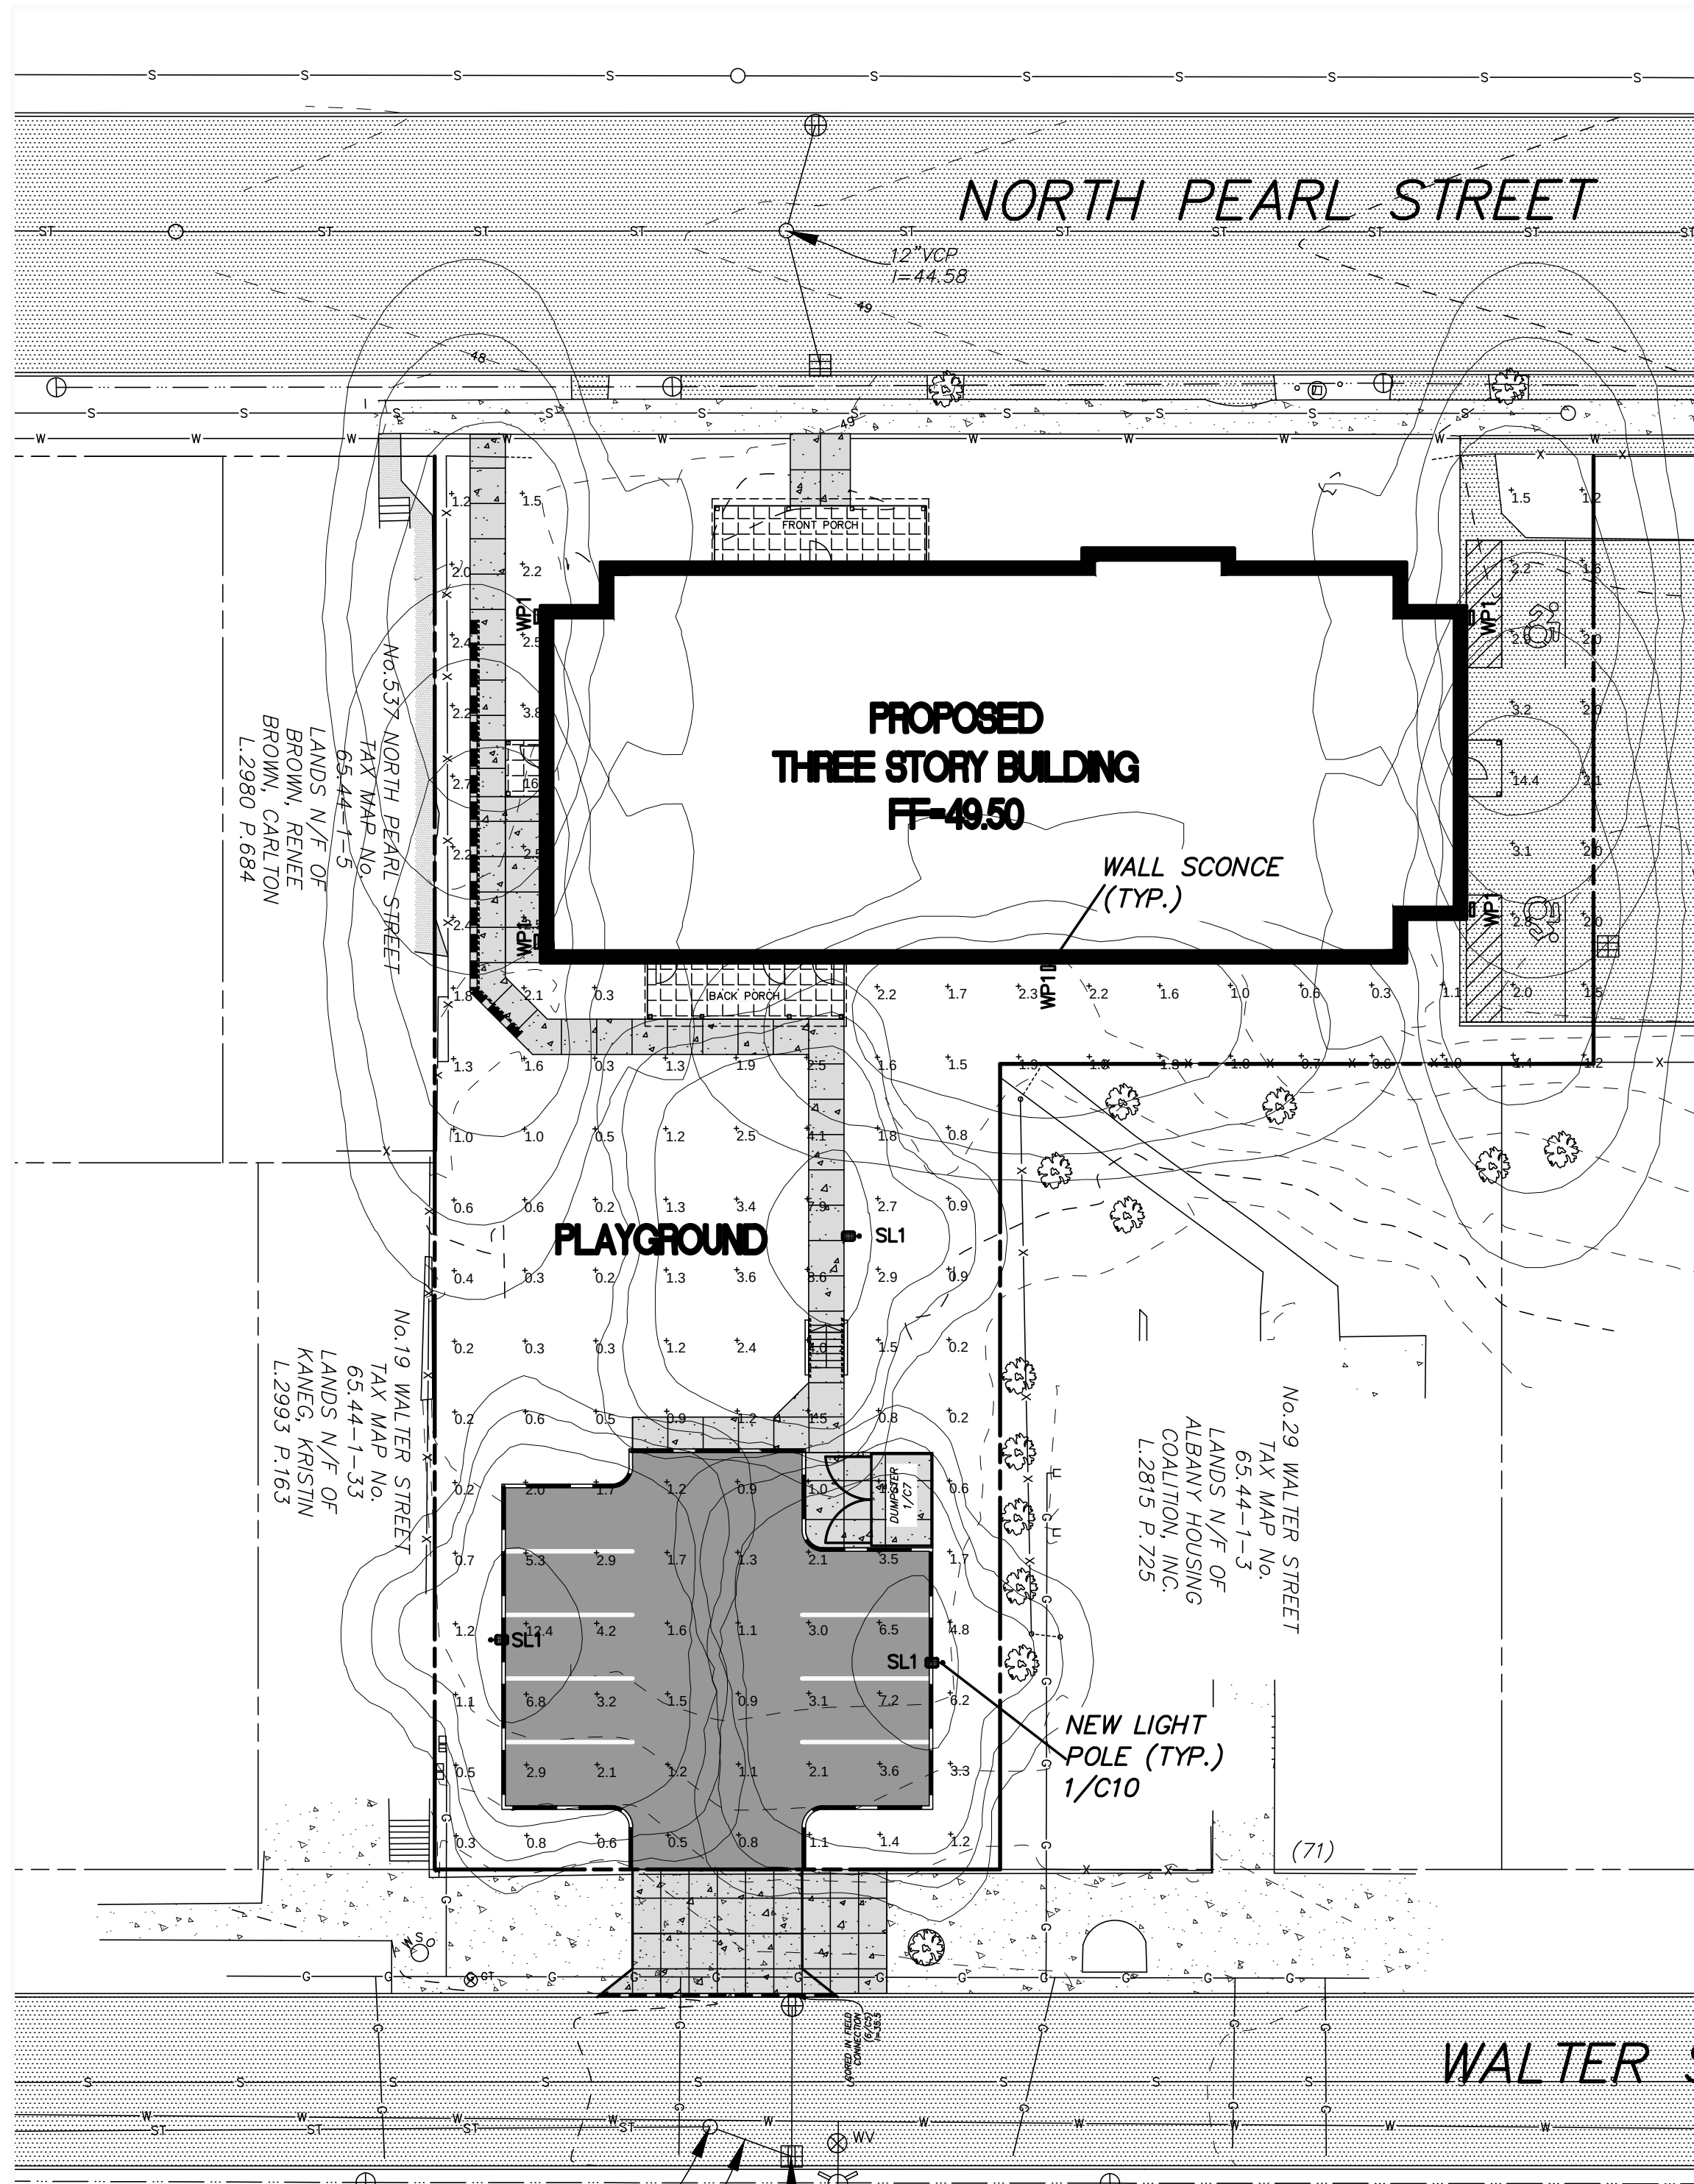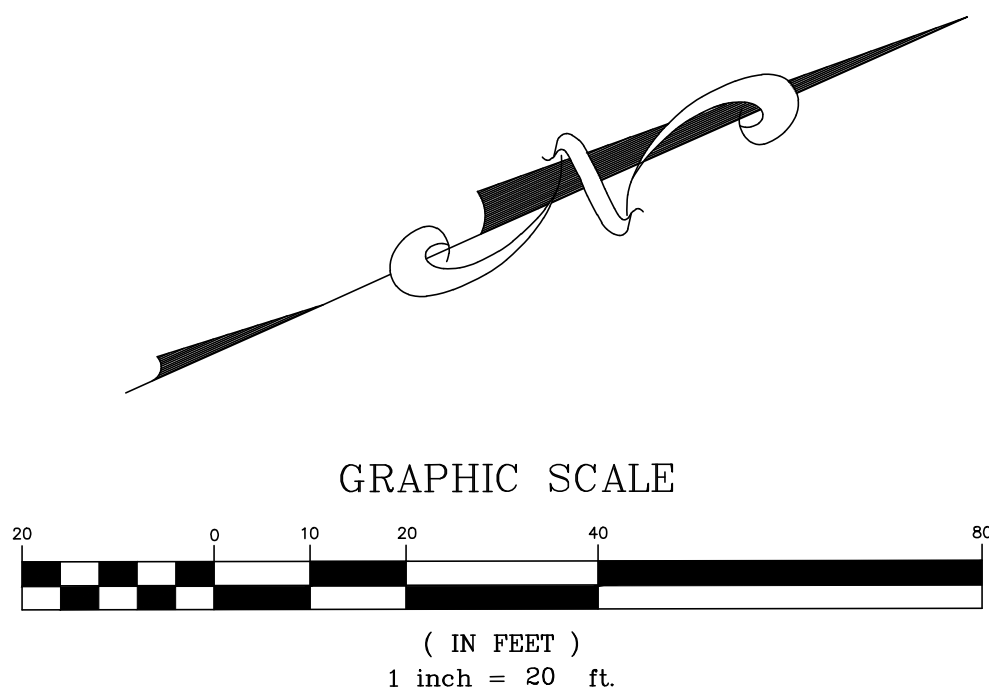

1/C10 LIGHT POLE DETAIL
NOT TO SCALE

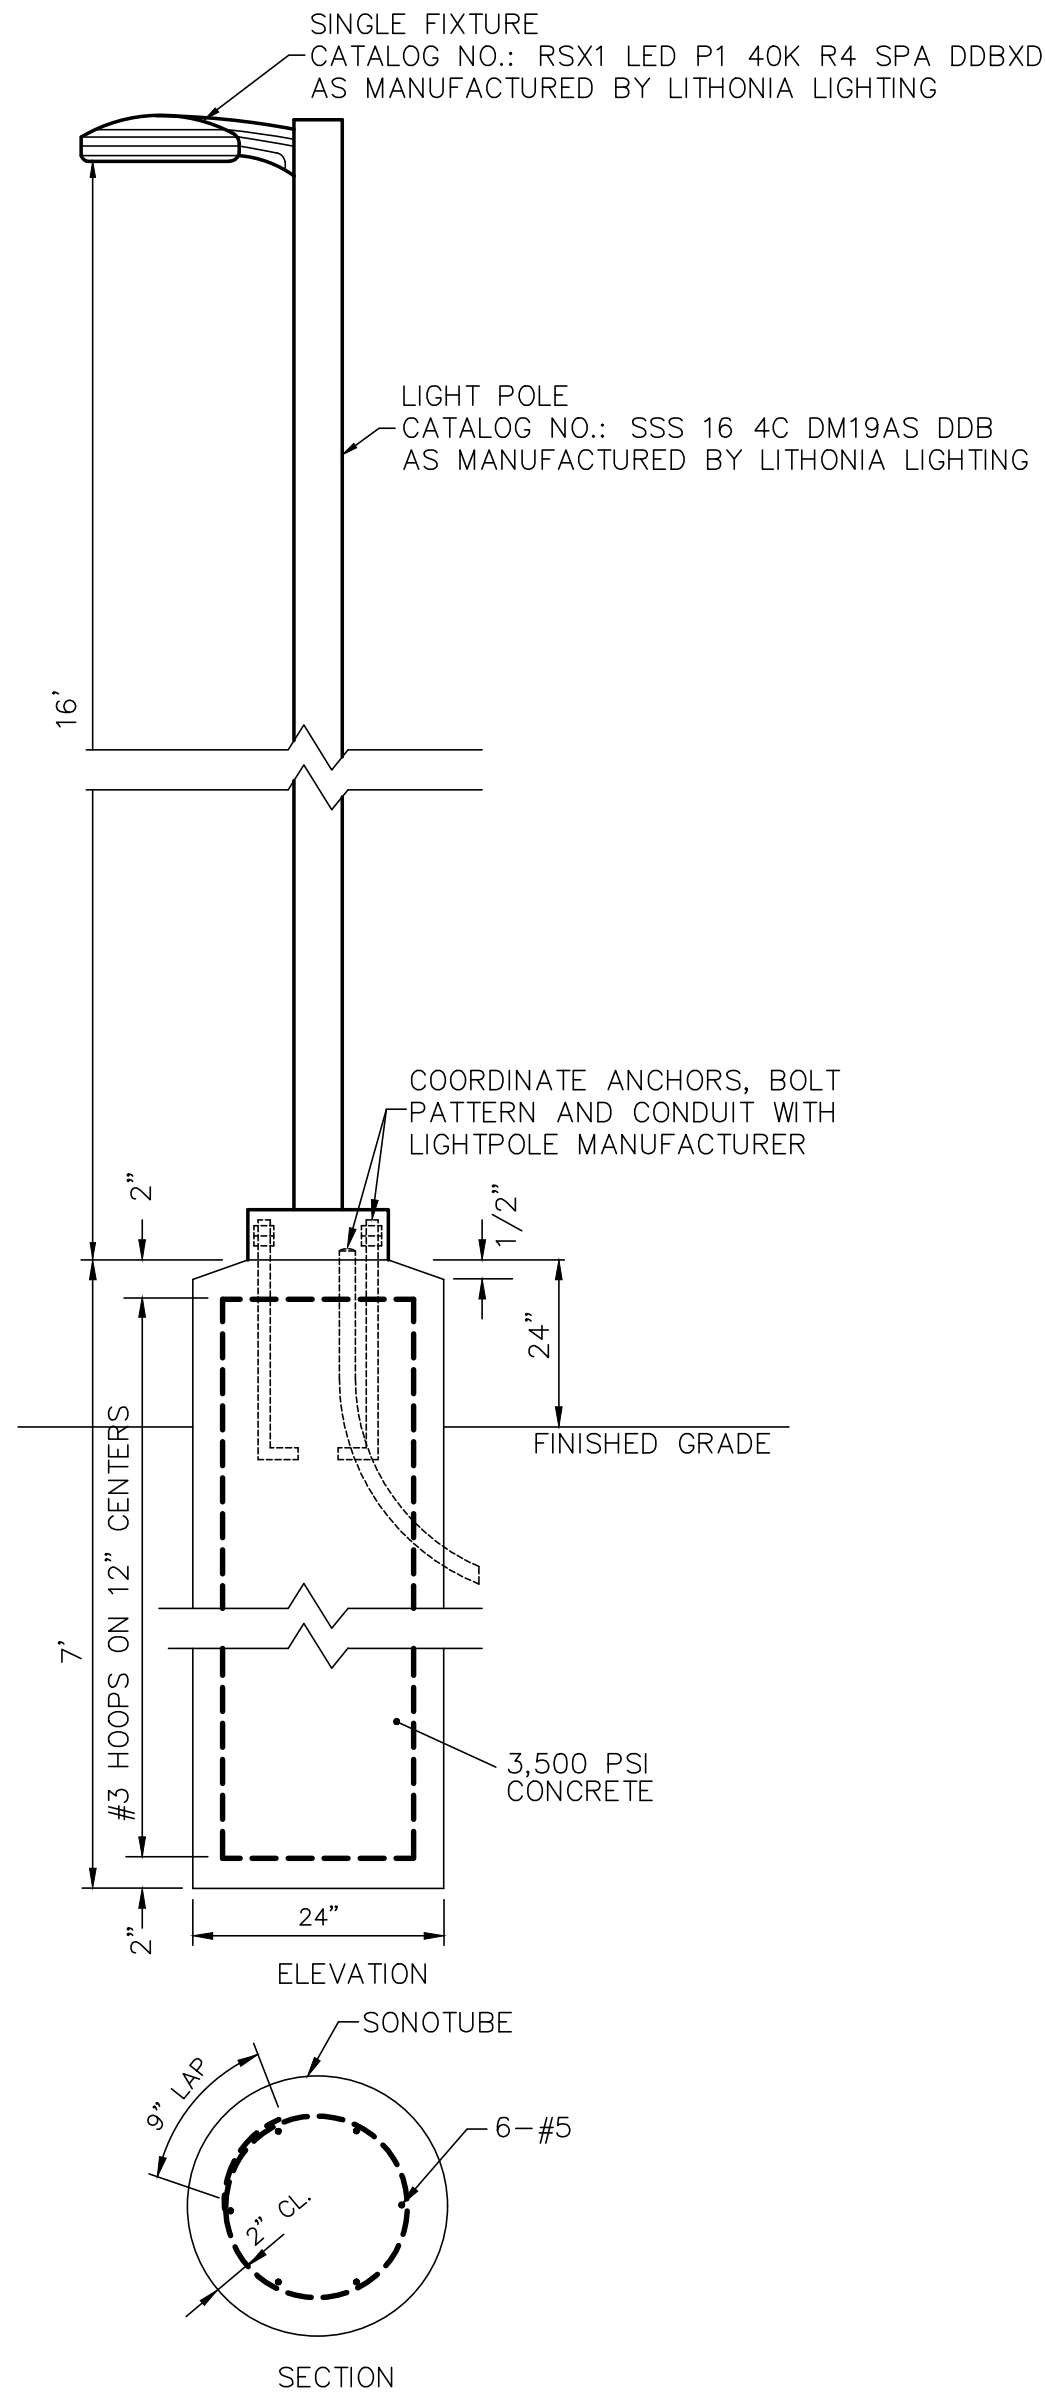

Schedule									
Symbol	Label	QTY	Catalog Number	Description	Lamp	Number Lamps	Lumens per Lamp	LLF	Wattage
	SL1	3	RSX1 LED P1 40K R4 SPA DDBXD SSS 16 4C DM19AS DDB	RSX Area Fixture Size 1 P1 Lumen Package 4000K CCT Type R4 Distribution	LED	1	7189	0.9	51.34
	WP1	5	DSXW2 LED 20C 700 40K T2M MVOLT	DSXW2 LED WITH 2 LIGHT ENGINES, 20 LED's, 700mA DRIVER, 4000K LED, TYPE 2 MEDIUM OPTIC	LED	1	4252	0.9	47

REVISIONS	DATE	REMARKS
1	1/2/19	LIGHTING REVISIONS
2	1/15/19	DEPT/ENGINEERING COMMENTS
3	1/16/19	
4		
5		