



BROADWAY

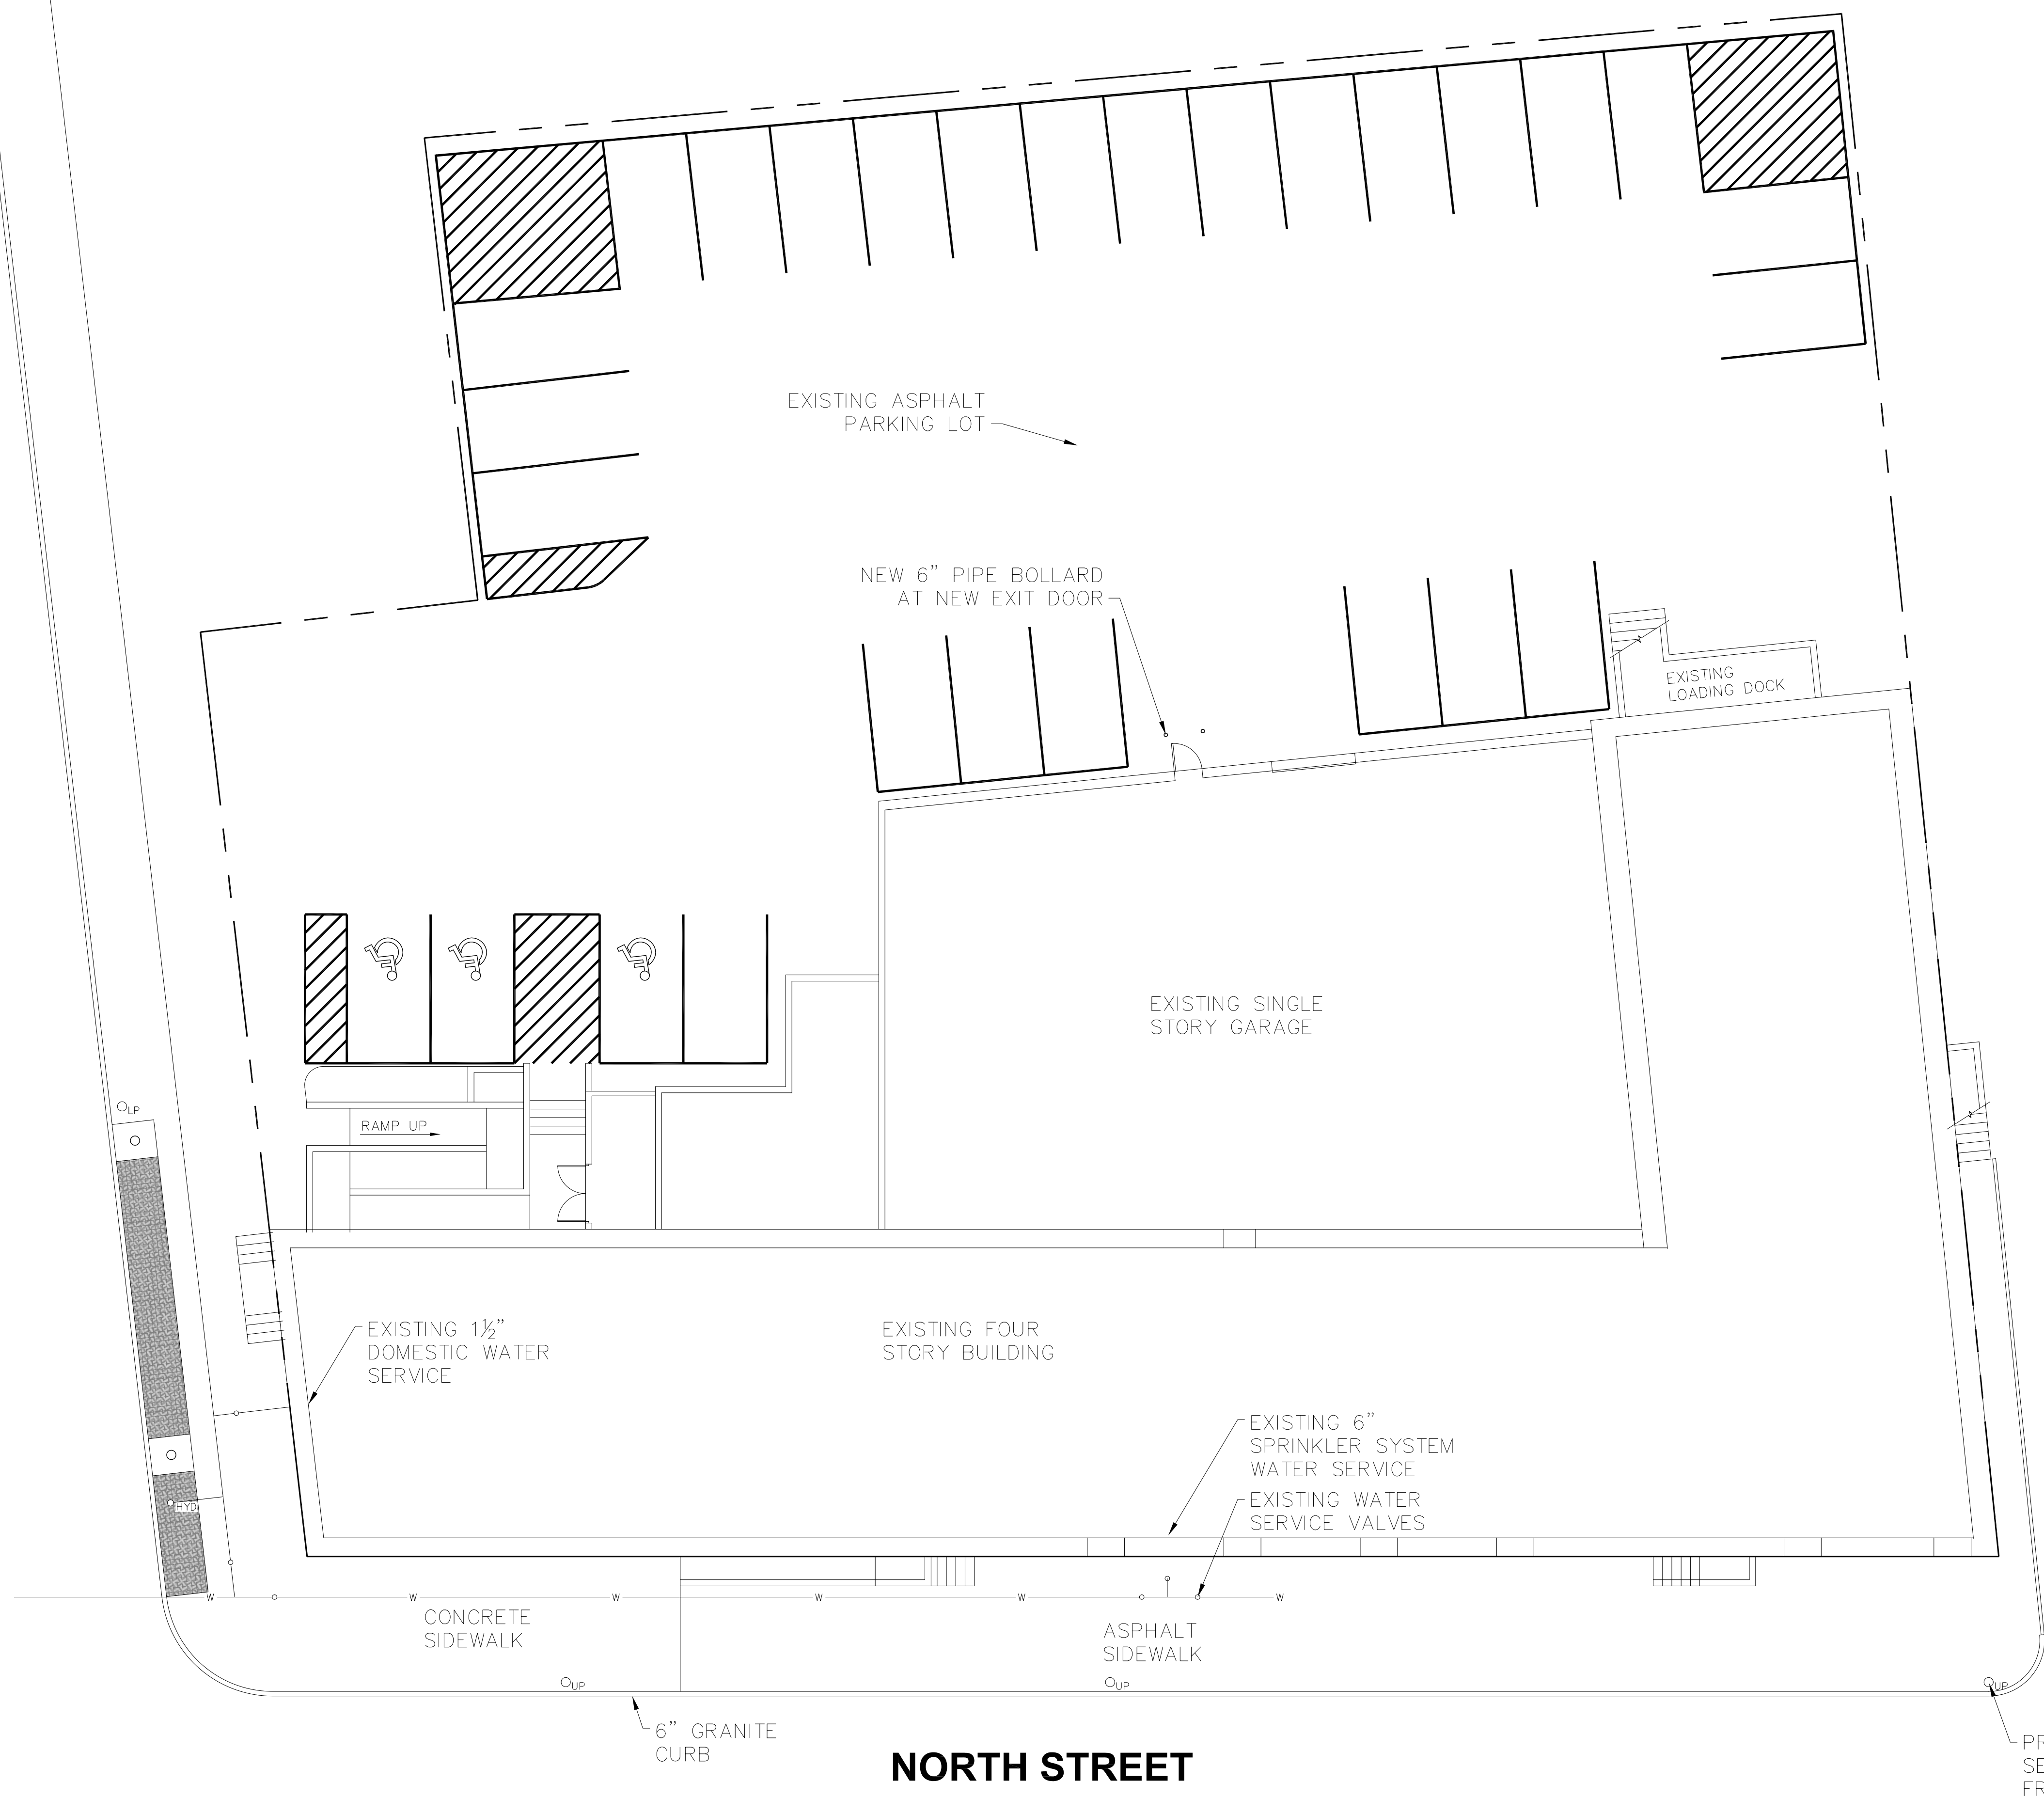

1 SITE PLAN
1" = 10'

- SITE NOTES:
1. PLUMBING CONTRACTOR IS RESPONSIBLE FOR APPLICATION FOR AND SECURING OF ALL WATER AND SEWER PERMITS AS REQUIRED BY THE CITY OF ALBANY.
 2. ALL ROOF LEADERS SHALL BE DISCONNECTED FROM AND RUN SEPARATELY FROM SANITARY SEWER PER THE REQUIREMENTS OF THE CITY OF ALBANY.
 3. EXISTING SANITARY SEWER SYSTEMS THAT REMAIN IN SERVICE AS PART OF THE COMPLETED PROJECT SHALL BE INSPECTED VIA VIDEO CAMERA WITH VIDEO SUBMITTED TO THE WATER DEPARTMENT FOR REVIEW AND ACCEPTANCE.
 4. PROVIDE 48 HOURS NOTICE TO THE WATER DEPARTMENT FOR ALL INSPECTIONS OF WATER, STORM, AND SANITARY SYSTEMS.
 5. CONTRACTOR SHALL PROVIDE PDF AND CAD FILES OF AS-BUILT DRAWINGS TO THE CITY PRIOR TO RECEIPT OF FINAL PAYMENT.

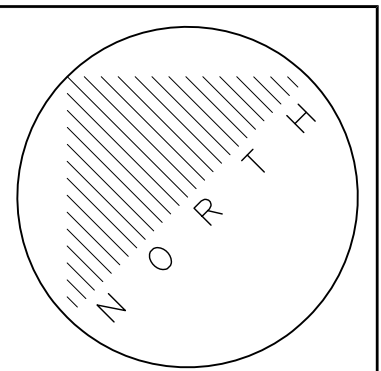

Designed By:	Date:
MJK	1-2-20
Drawn By:	Date:
MJK	1-4-20
Checked By:	Date:
MJK	1-14-20

UNAUTHORIZED ALTERATION OR ADDITION TO THIS DOCUMENT IS PROHIBITED BY SECTION 2 OF THE NEW YORK STATE EDUCATION LAW

Shamrock Engineering P.C.
1 THURSH TERRACE - EAST GREENBUSH, NEW YORK - 12061
(518) 441-6148
Project No. 19055

Renovation of 883 Broadway
for 883 BROADWAY of ALBANY, LLC
ALBANY, NEW YORK
883 BROADWAY
SITE PLAN PLAN
SCALE: AS NOTED
DATE: JANUARY 2020

App'd.:	Date:
MJK	1-21-20
Revisions:	
0. ISSUED FOR REVIEW	

Drawing No.
C100

PRIMARY ELECTRIC SERVICE TO BASEMENT FROM THIS POLE